

Bradley
Corporation

www.bradleycorp.com

Bradley BIM | Revit Support Portal
www.bradleybim.com

Bradley BIM | Revit Library
www.bradleycorp.com/bim
[1,000 Revit Families]

This Bradley VDC-Assist Starter Kit is a 'Not for Construction' drawing. Copy/Paste the Plan Model View of the layout into your Revit Project.

The designer, client and/or owner are responsible for completing the layout and obtaining all federal, state and local code reviews, permits & approvals for this layout.

Included:


- (1) 2D 30x48 Clearance Box & (1) 5' Diameter Wheelchair Clearance Circle created with Revit Symbolic Lines.
- (1) 3D Revit Wheelchair Family w/2 Family Types: 5' Diameter & T-Shaped Turn Around Clearance Space
- (1) 3D/2D Wheelchair Knee-Toe Clearance Revit Family

Bradley VDC-Assist
Single Toilet Room
Accessible Toilet
Room Sample


Project number	Project Number
Date	Issue Date
Drawn by	www.BradleyBIM.com
Checked by	Checker

A100


Scale
1/2" = 1'-0"

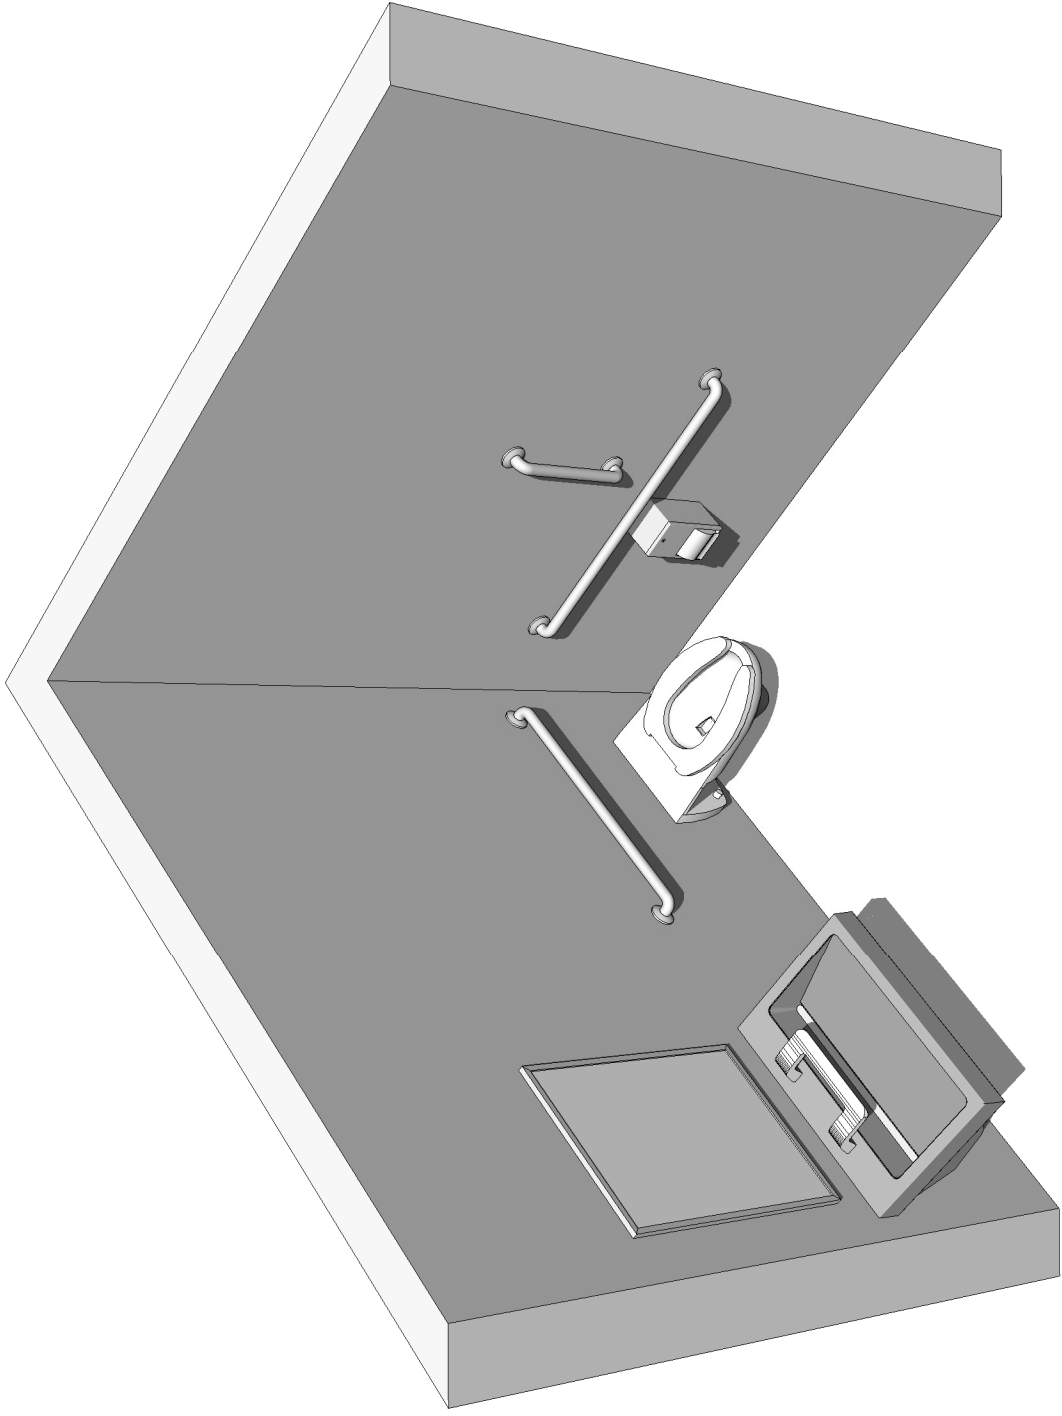


2 PERSPECTIVE VIEW

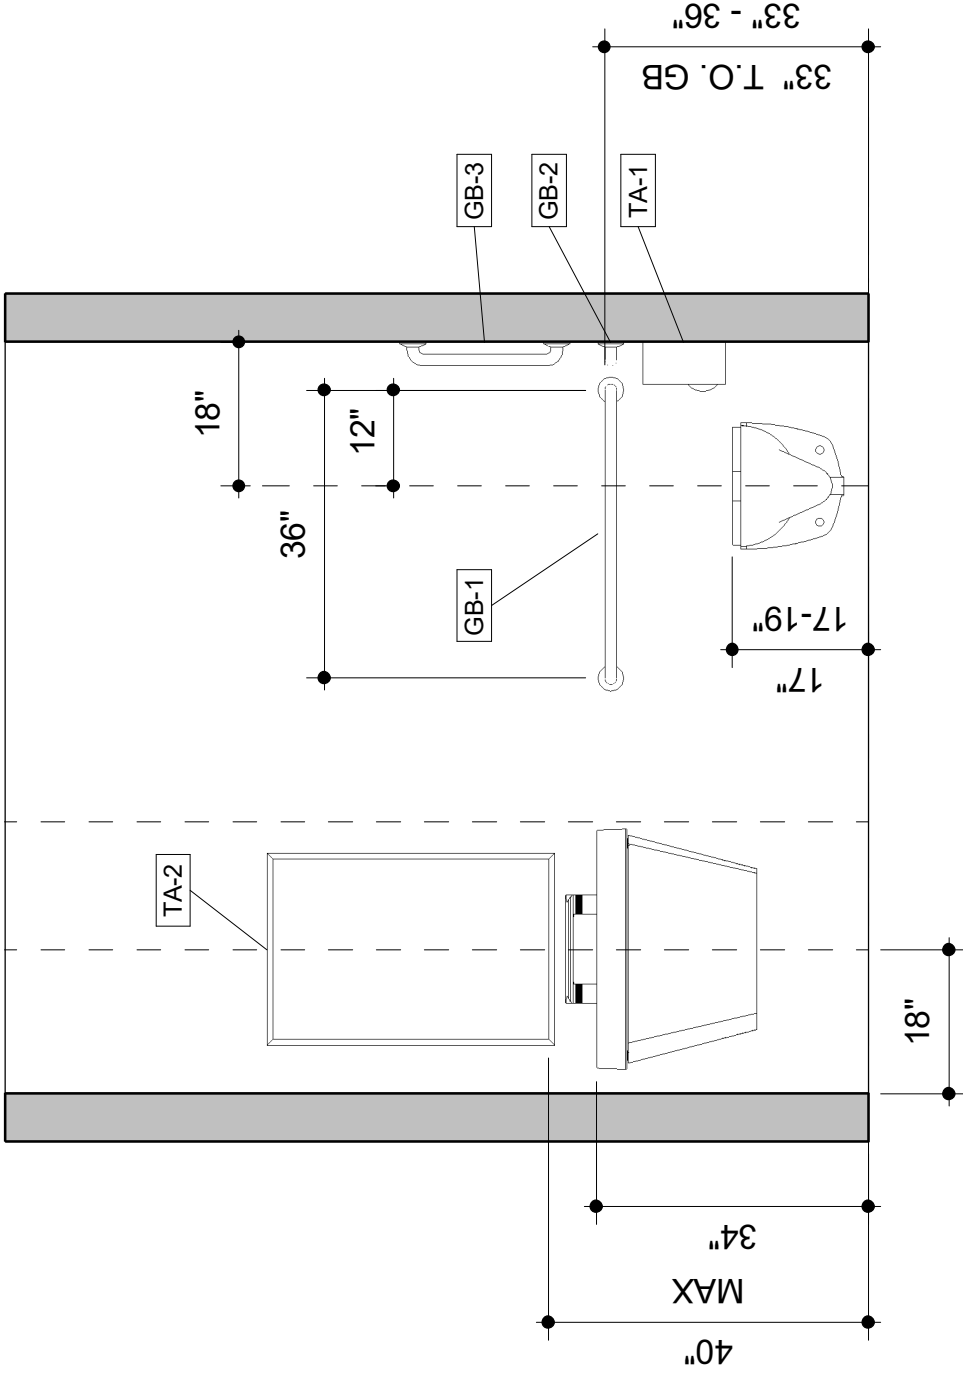

4 FRONT | ACCESSIBLE TOILET ROOM
1/2" = 1'-0"

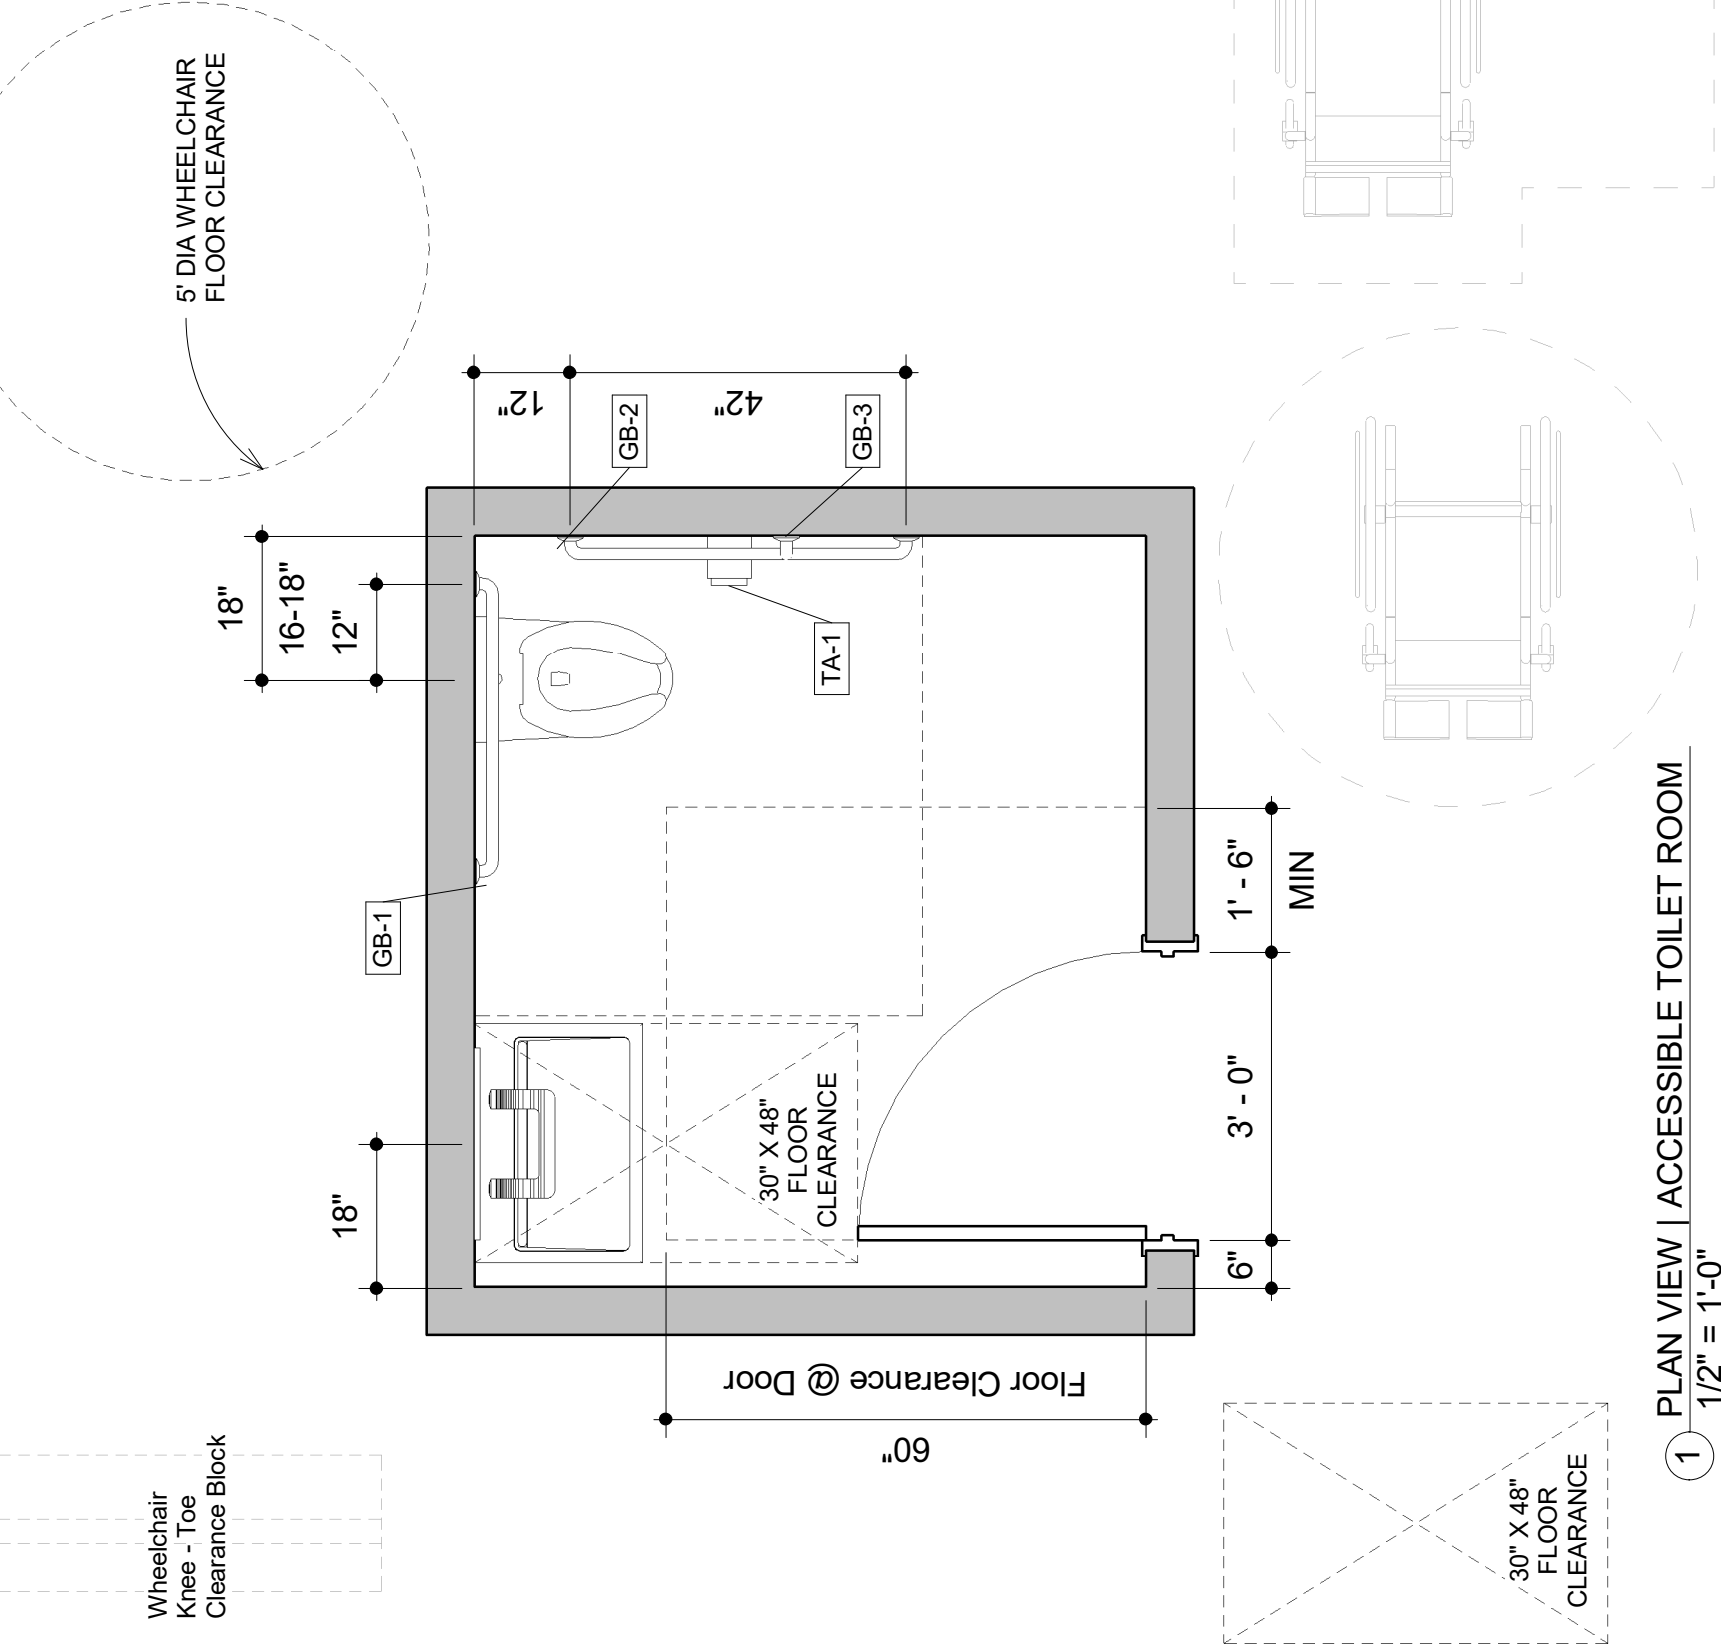

1 PLAN VIEW | ACCESSIBLE TOILET ROOM
1/2" = 1'-0"

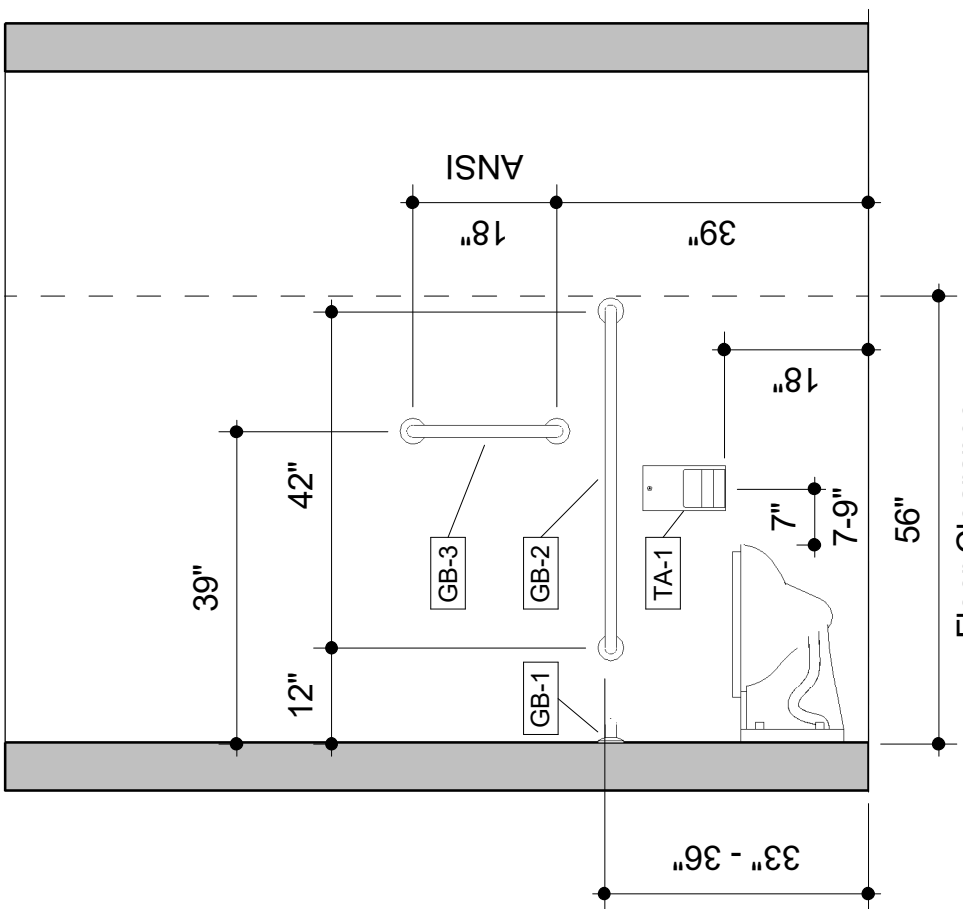

3 LEFT VIEW | ACCESSIBLE TOILET ROOM
1/2" = 1'-0"

Bradley Corporation

www.bradleycorp.com

Bradley BIM \ Revit Support Portal
www.bradleybim.com

Bradley BIM | Revit Library
www.bradleycorp.com/bim
[1,000 Revit Families]

This Bradley VDC-Assist Starter Kit is a 'Not for Construction' drawing. Copy/Paste the Plan Model View of the layout into your Revit Project.

The designer, client and/or owner are responsible for completing the layout and obtaining all federal, state and local code reviews, permits & approvals for this layout.

Included:

- (1) 2D 30x48 Clearance Box & (1) 5' Diameter Wheelchair Clearance Circle created with Revit Symbolic Lines.
- (1) 3D Revit Wheelchair Family w/2 Family Types: 5' Diameter & T-Shaped Turn Around Clearance Space
- (1) 3D/2D Wheelchair Knee-Toe Clearance Revit Family

Bradley VDC-Assist Single Toilet Room SCHEDULES

Project number	Project Number
Date	Issue Date
Drawn by	Author
Checked by	Checker

A101


Scale	1/2" = 1'-0"
-------	--------------

Specialty Equipment Schedule			
Count	Mark	Description	Manufacturer

1	GB-1	Grab Bars	Bradley Corporation
1	GB-2	Grab Bars	Bradley Corporation
1	GB-3	Grab Bars	Bradley Corporation
1	TA-1	Toilet Tissue Dispenser	Bradley Corporation
1	TA-2	Channel-Frame Mirror, Welded Corners, 24x36	Bradley Corporation

Plumbing Fixture Schedule			
Count	Mark	Description	Manufacturer

1	LAV-1	Verge™ Lavatory System w/Washbar Technology – LVQ Series, One Station	Bradley Corporation
---	-------	---	---------------------

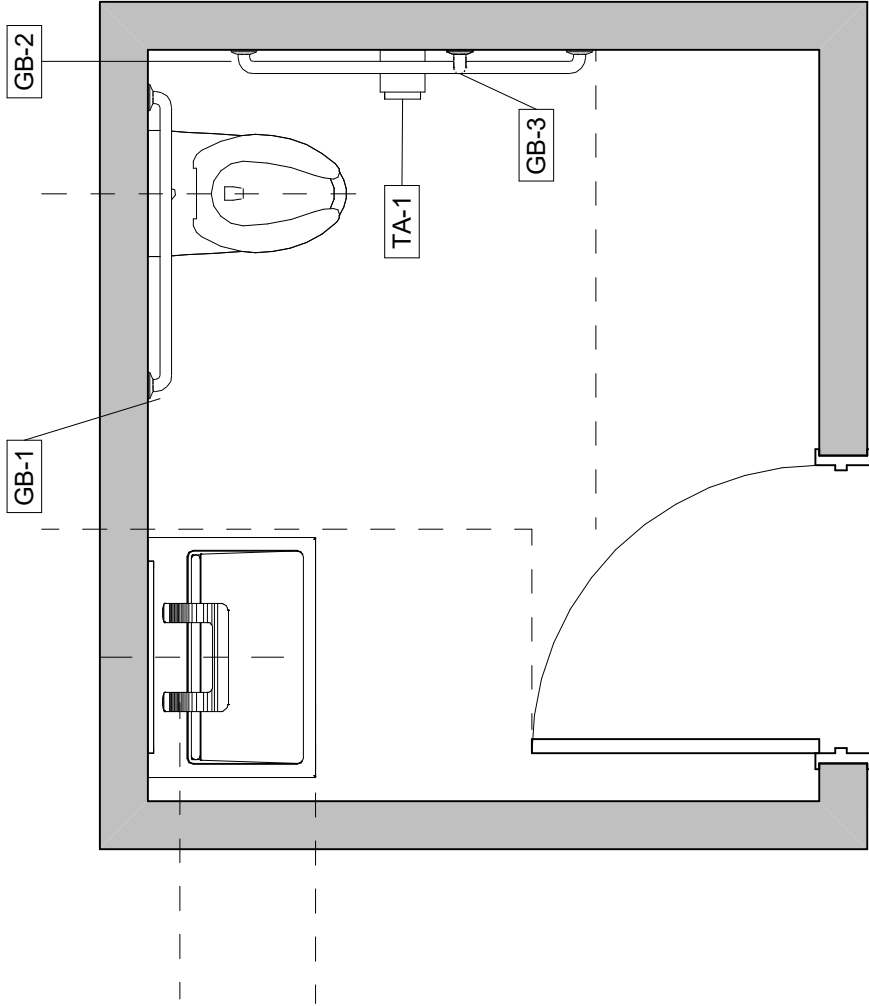

1 PLAN VIEW | ADA TOILET ROOM
1/2" = 1'-0"