

Bradley Corporation

www.bradleycorp.com

Bradley BIM | Revit Support Portal
www.bradleybim.com

Bradley BIM | Revit Library
www.bradleycorp.com/bim
[1,000 Revit Families]

This Bradley VDC-Assist Starter Kit is a 'Not for Construction' drawing. Copy/Paste the Plan Model View of the layout into your Revit Project.

The designer, client and/or owner are responsible for completing the layout and obtaining all federal, state and local code reviews, permits & approvals for this layout.

Included:


- (1) 2D 30x48 Clearance Box & (1) 5' Diameter Wheelchair Clearance Circle created with Revit Symbolic Lines.
- (1) 3D Revit Wheelchair Family w/2 Family Types: 5' Diameter & T-Shaped Turn Around Clearance Space
- (1) 3D/2D Wheelchair Knee-Toe Clearance Revit Family


Bradley Corporation VDC-Assist FLOOR PLAN

Project number	Project Number
Date	Issue Date
Drawn by	Author
Checked by	Checker


A100

Scale 3/8" = 1'-0"

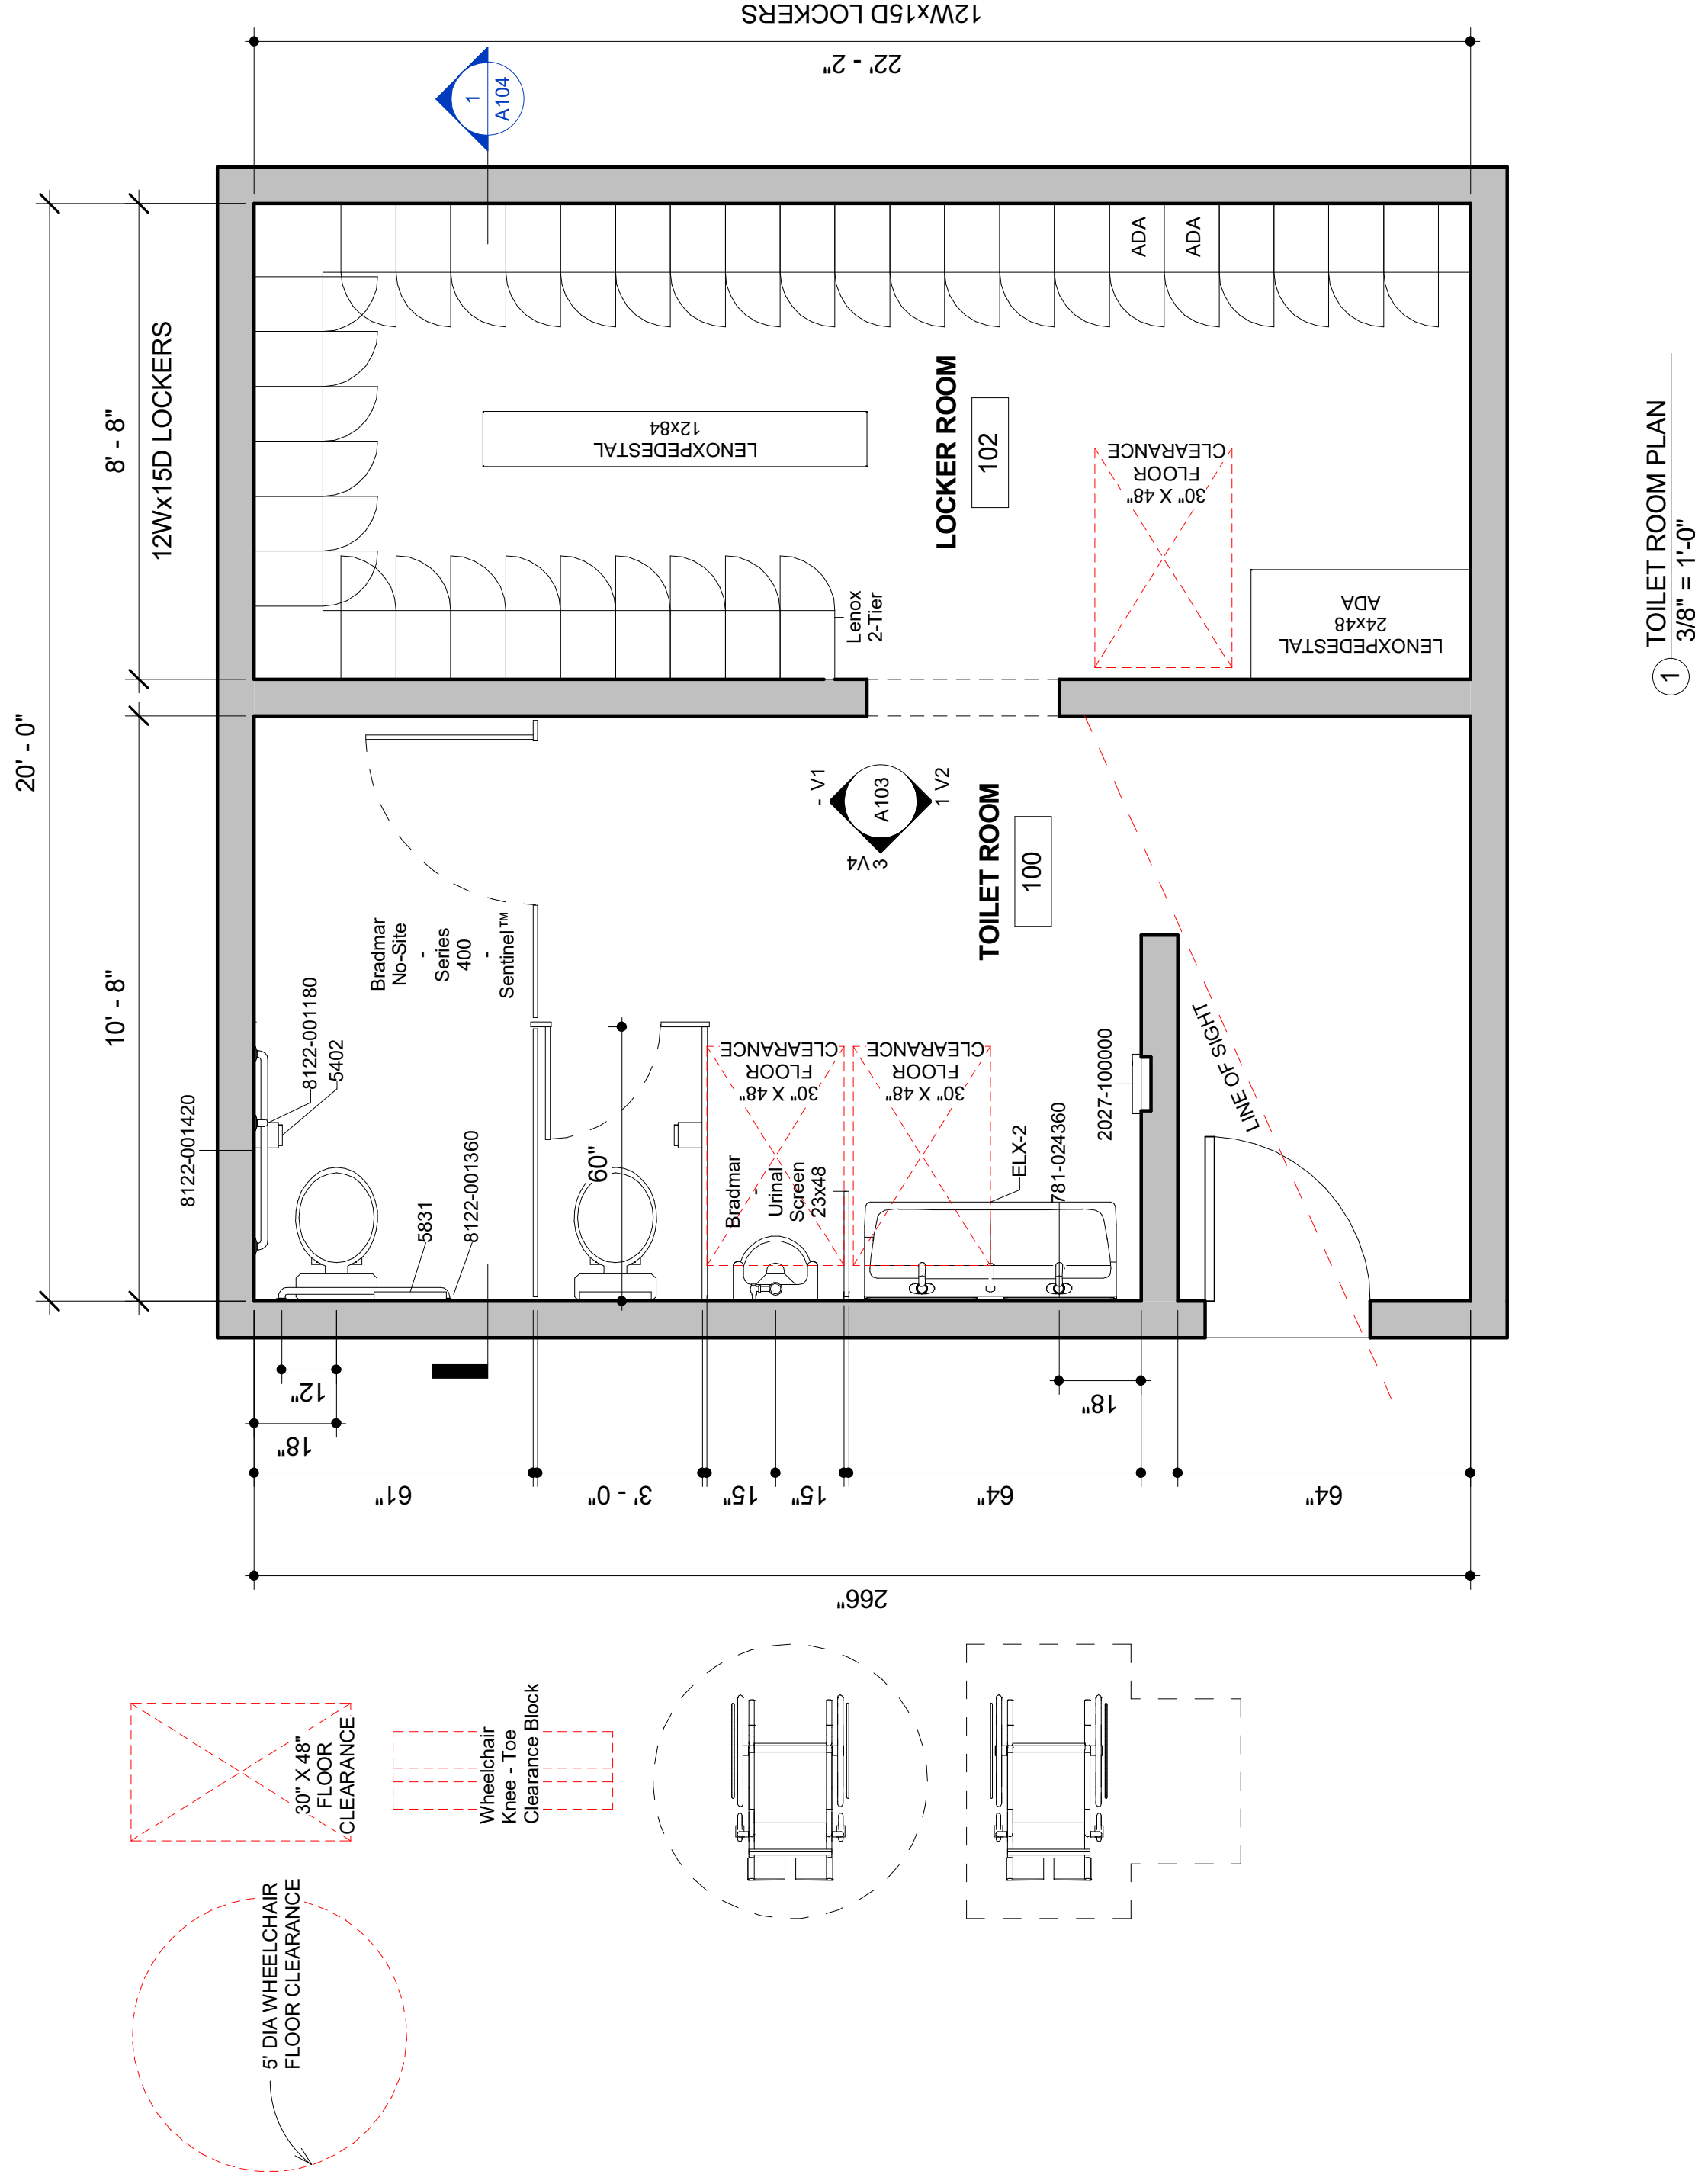


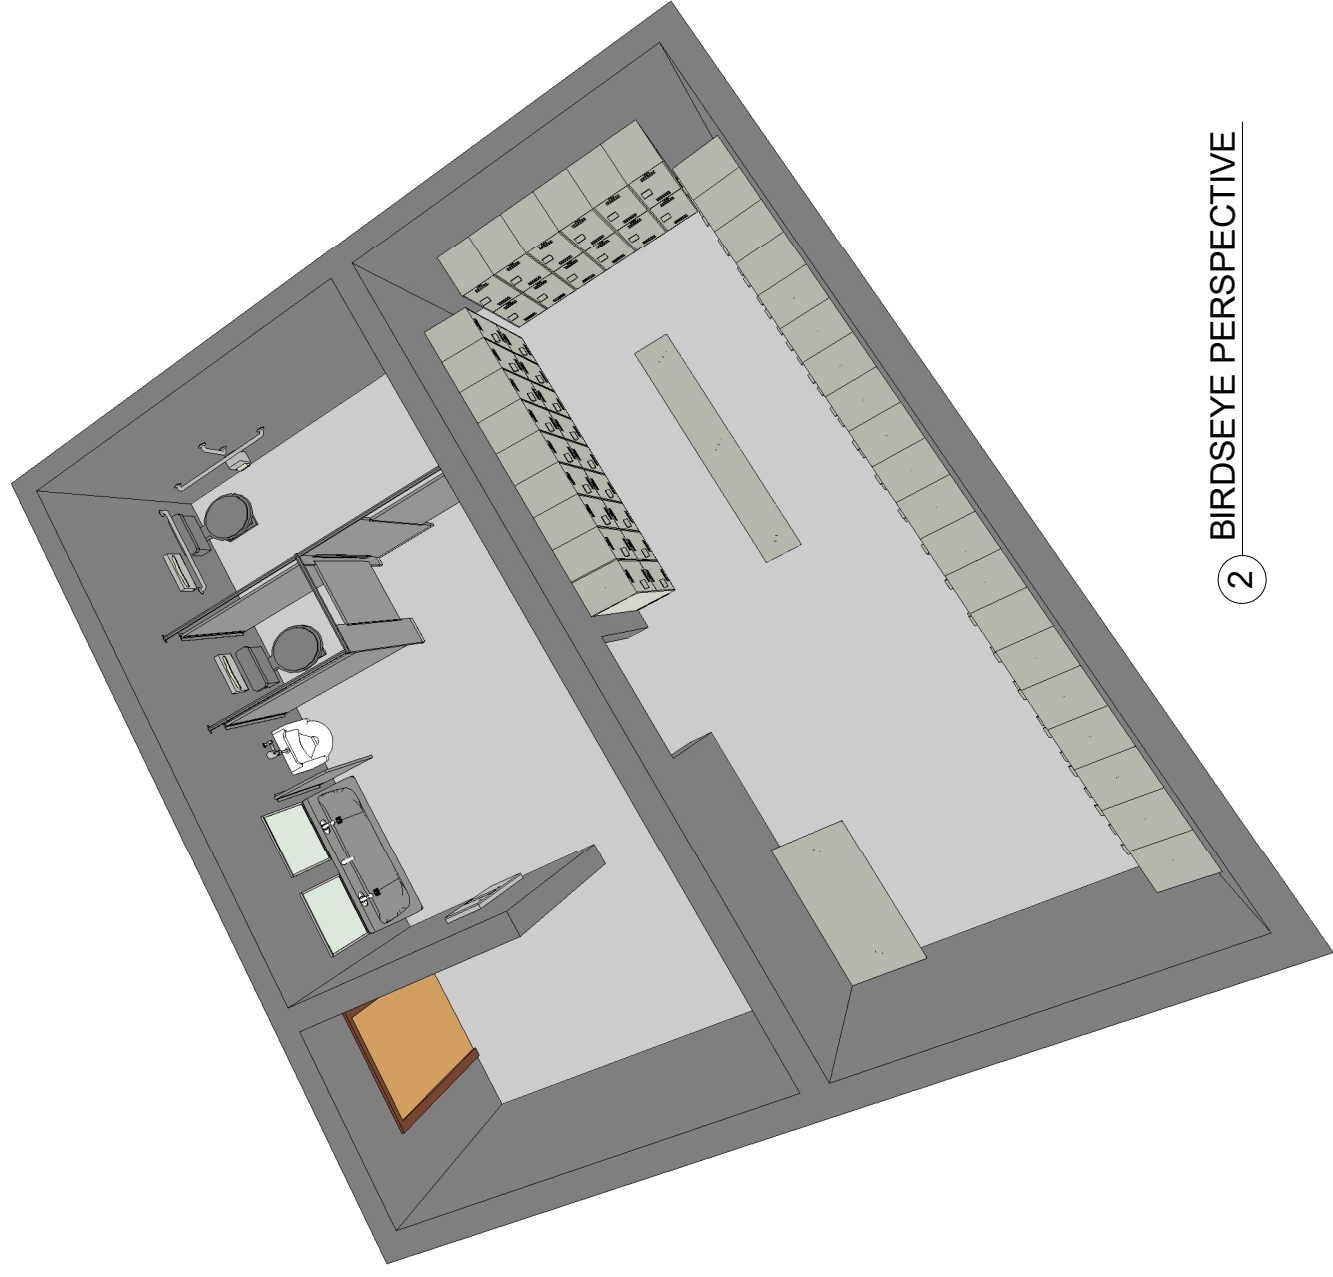

② BIRDSEYE PERSPECTIVE

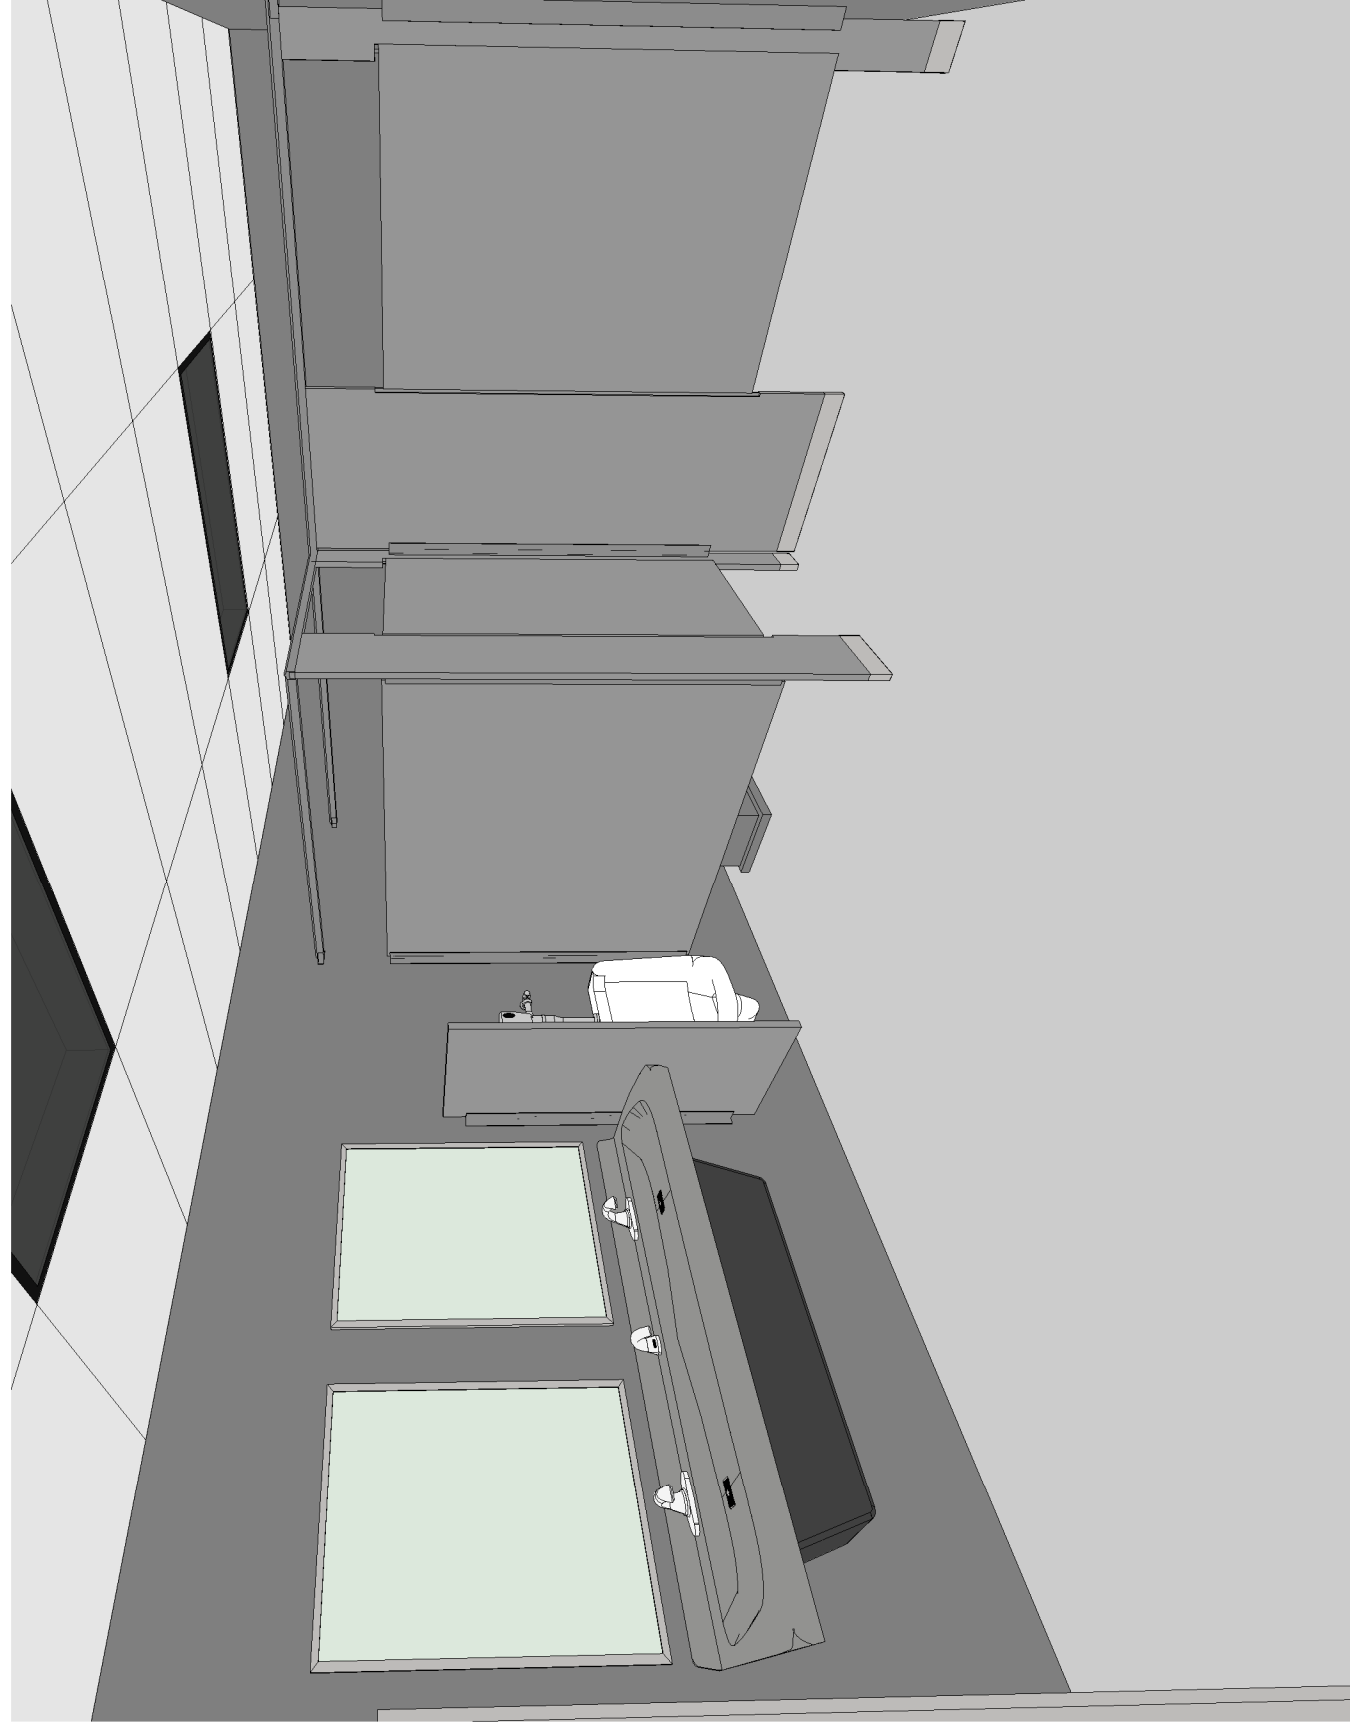

① INTERIOR PERSPECTIVE

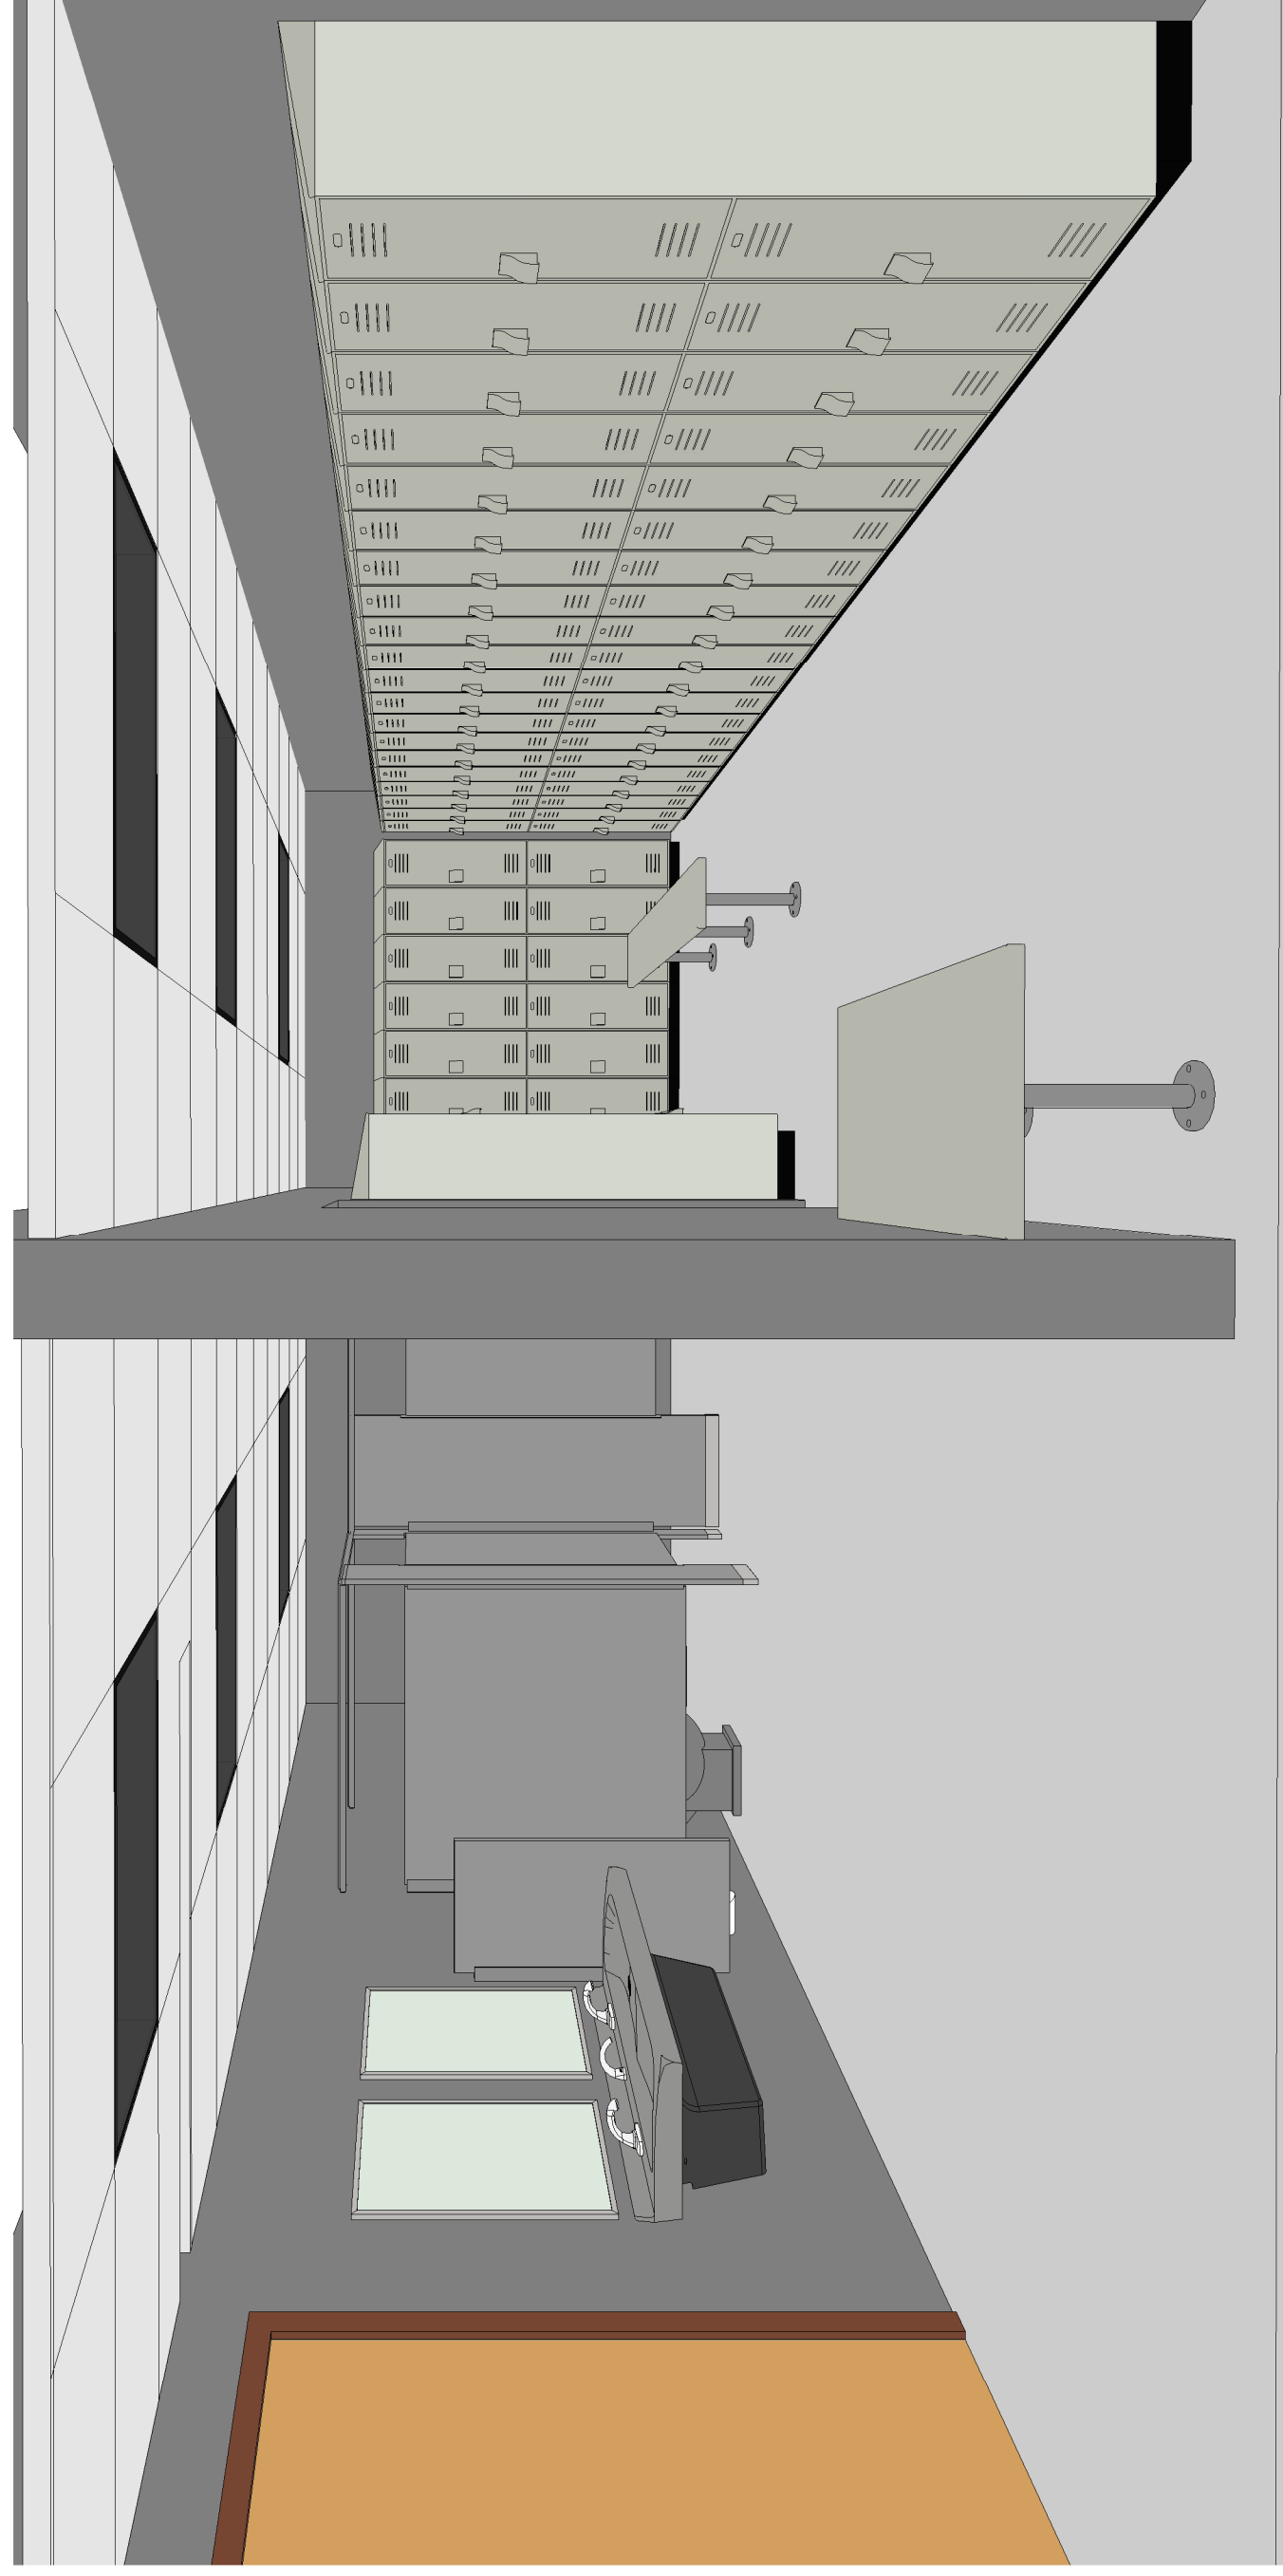

③ 3D View 2

Bradley Corporation

www.bradleycorp.com

Bradley BIM | Revit Support Portal
www.bradleybim.com

Bradley BIM | Revit Library
www.bradleycorp.com/bim
[1,000 Revit Families]

This Bradley VDC-Assist Starter Kit is a 'Not for Construction' drawing. Copy/Paste the Plan Model View of the layout into your Revit Project.

The designer, client and/or owner are responsible for completing the layout and obtaining all federal, state and local code reviews, permits & approvals for this layout.

Included:

- (1) 2D 30x48 Clearance Box & (1) 5' Diameter Wheelchair Clearance Circle created with Revit Symbolic Lines.
- (1) 3D Revit Wheelchair Family w/2 Family Types: 5' Diameter & T-Shaped Turn Around Clearance Space
- (1) 3D/2D Wheelchair Knee-Toe Clearance Revit Family

Bradley Corporation VDC-Assist 3D PLANS & VIEWS

Project number	Project Number
Date	Issue Date
Drawn by	Author
Checked by	Checker

A102

Scale

Bradley Corporation

www.bradleycorp.com

Bradley BIM | Revit Support Portal
www.bradleybim.com

Bradley BIM | Revit Library
www.bradleycorp.com/bim
[1,000 Revit Families]

This Bradley VDC-Assist Starter Kit is a 'Not for Construction' drawing. Copy/Paste the Plan Model View of the layout into your Revit Project.

The designer, client and/or owner are responsible for completing the layout and obtaining all federal, state and local code reviews, permits & approvals for this layout.

Included:


- (1) 2D 30x48 Clearance Box & (1) 5' Diameter Wheelchair Clearance Circle created with Revit Symbolic Lines.
- (1) 3D Revit Wheelchair Family w/2 Family Types: 5' Diameter & T-Shaped Turn Around Clearance Space
- (1) 3D/2D Wheelchair Knee-Toe Clearance Revit Family

Bradley Corporation VDC-Assist Elevations



Project number	Project Number
Date	Issue Date
Drawn by	Author
Checked by	Checker

A103

Scale 1/2" = 1'-0"

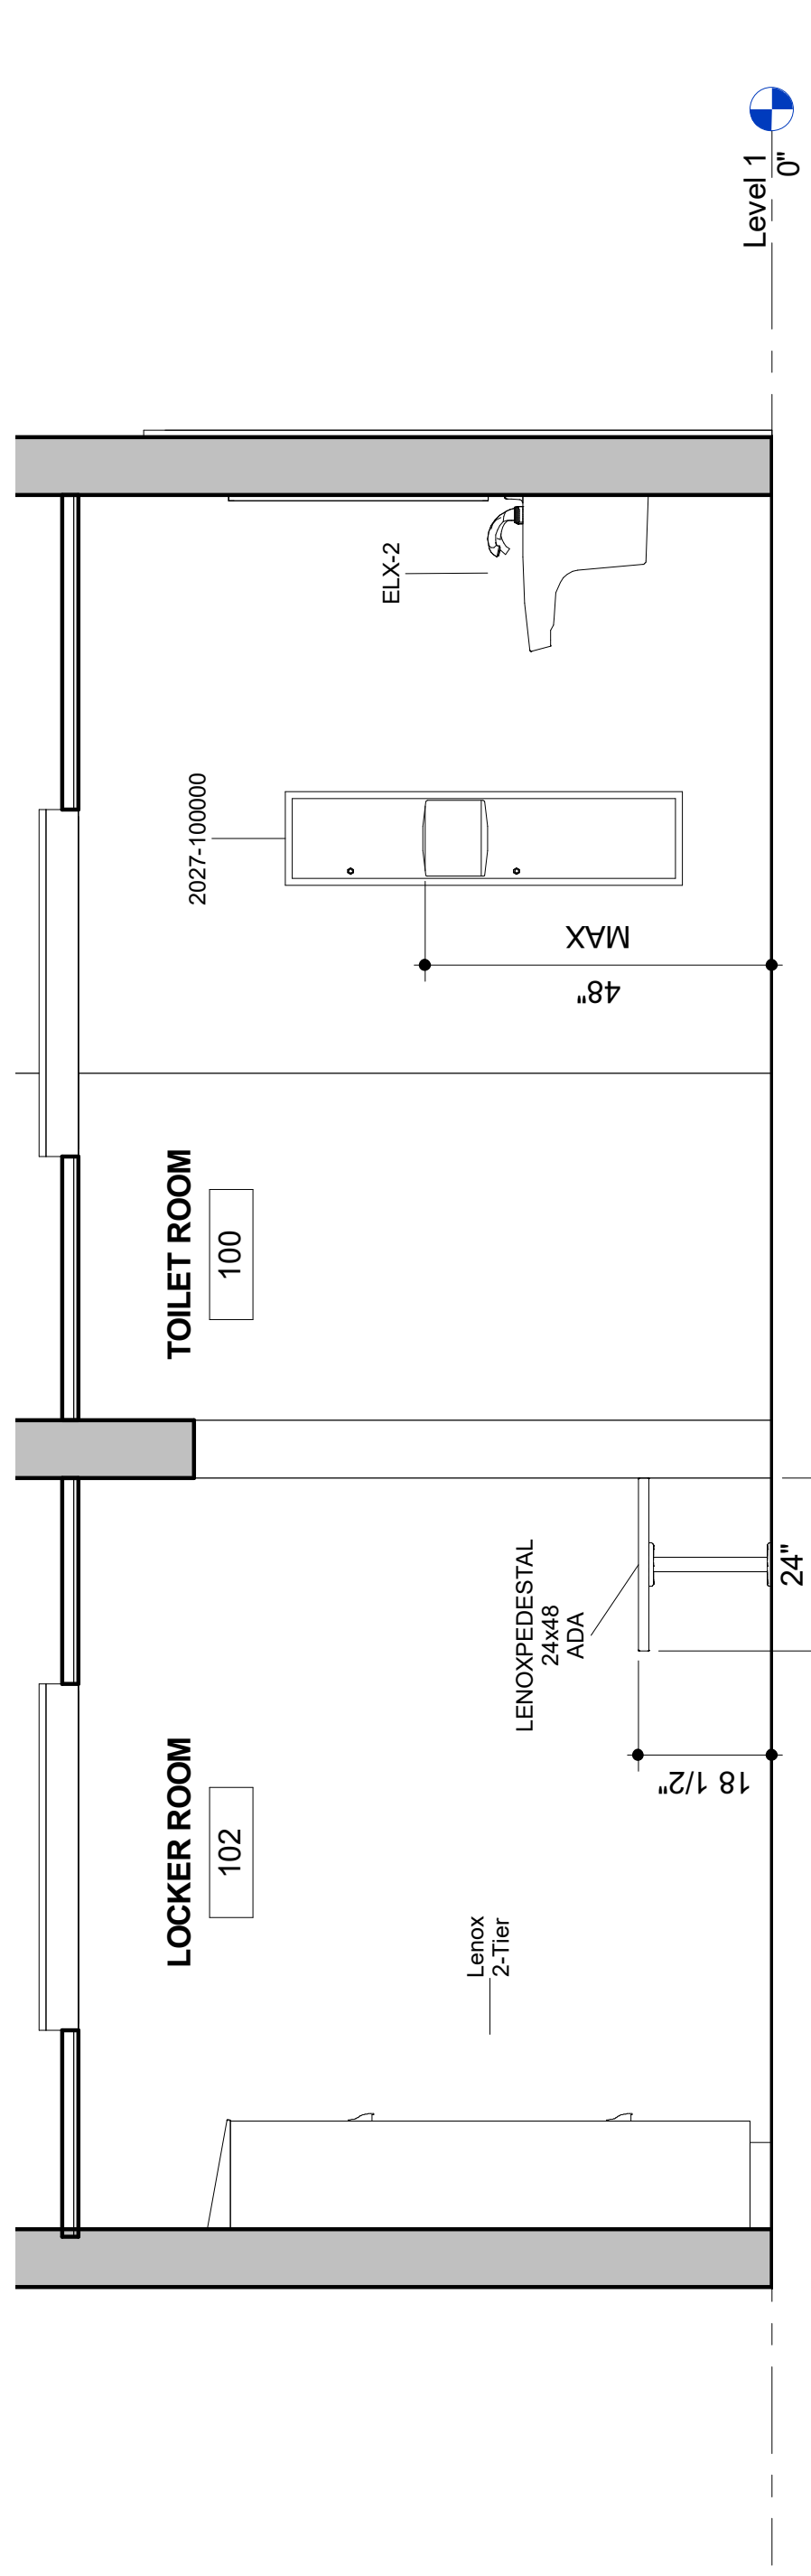

1 Elevation
1/2" = 1'-0"

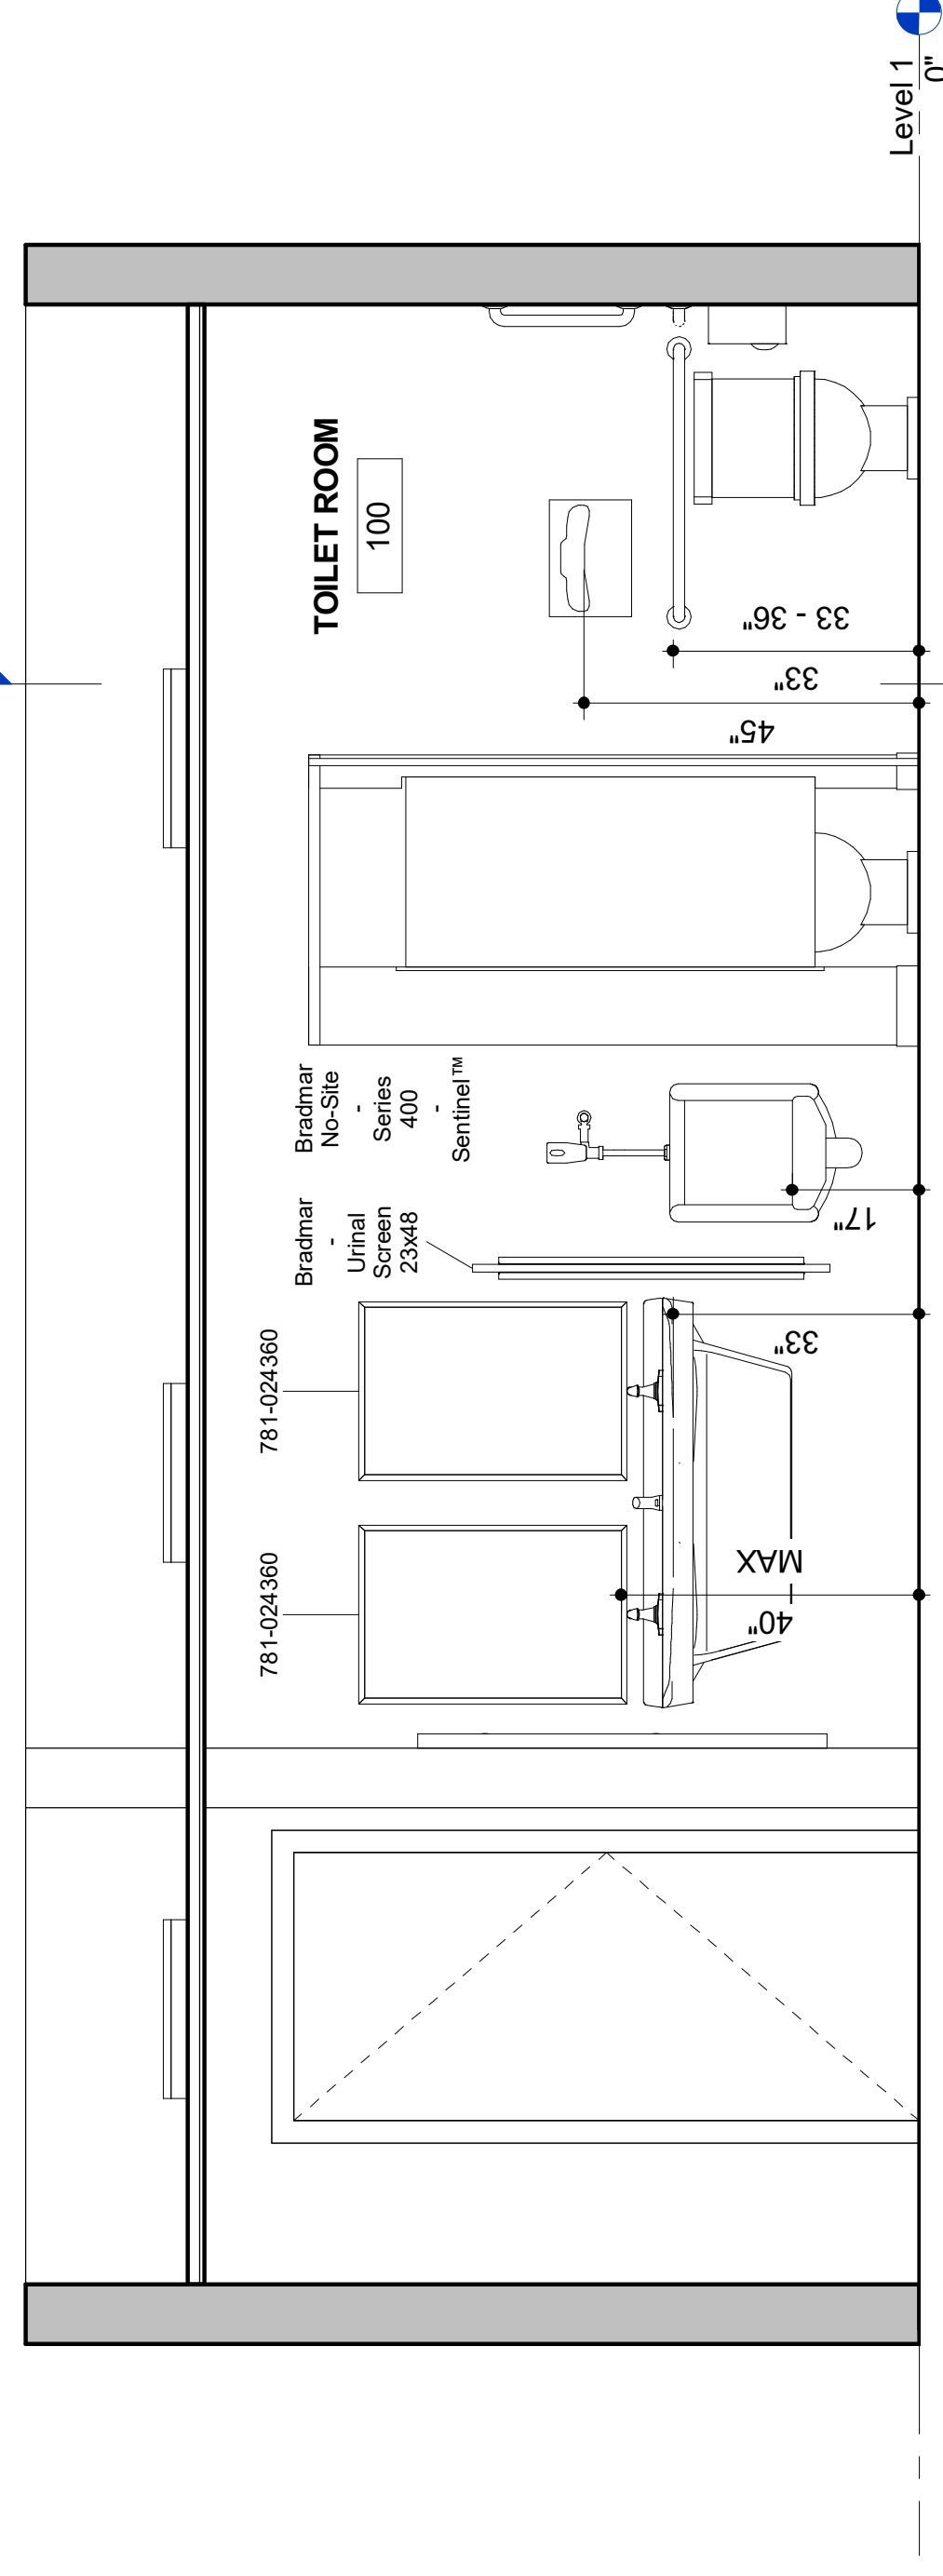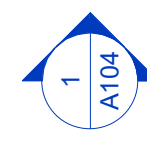

3 Elevation
1/2" = 1'-0"

Bradley Corporation

www.bradleycorp.com

Bradley BIM | Revit Support Portal
www.bradleybim.com

Bradley BIM | Revit Library
www.bradleycorp.com/bim
[1,000 Revit Families]

This Bradley VDC-Assist Starter Kit is a 'Not for Construction' drawing. Copy/Paste the Plan Model View of the layout into your Revit Project.

The designer, client and/or owner are responsible for completing the layout and obtaining all federal, state and local code reviews, permits & approvals for this layout.

Included:


- (1) 2D 30x48 Clearance Box & (1) 5' Diameter Wheelchair Clearance Circle created with Revit Symbolic Lines.
- (1) 3D Revit Wheelchair Family w/2 Family Types: 5' Diameter & T-Shaped Turn Around Clearance Space
- (1) 3D/2D Wheelchair Knee-Toe Clearance Revit Family

Bradley Corporation VDC-Assist Fixture - Accessory Schedules

Project number	Project Number
Date	Issue Date
Drawn by	Author
Checked by	Checker

A104

Scale 1/2" = 1'-0"

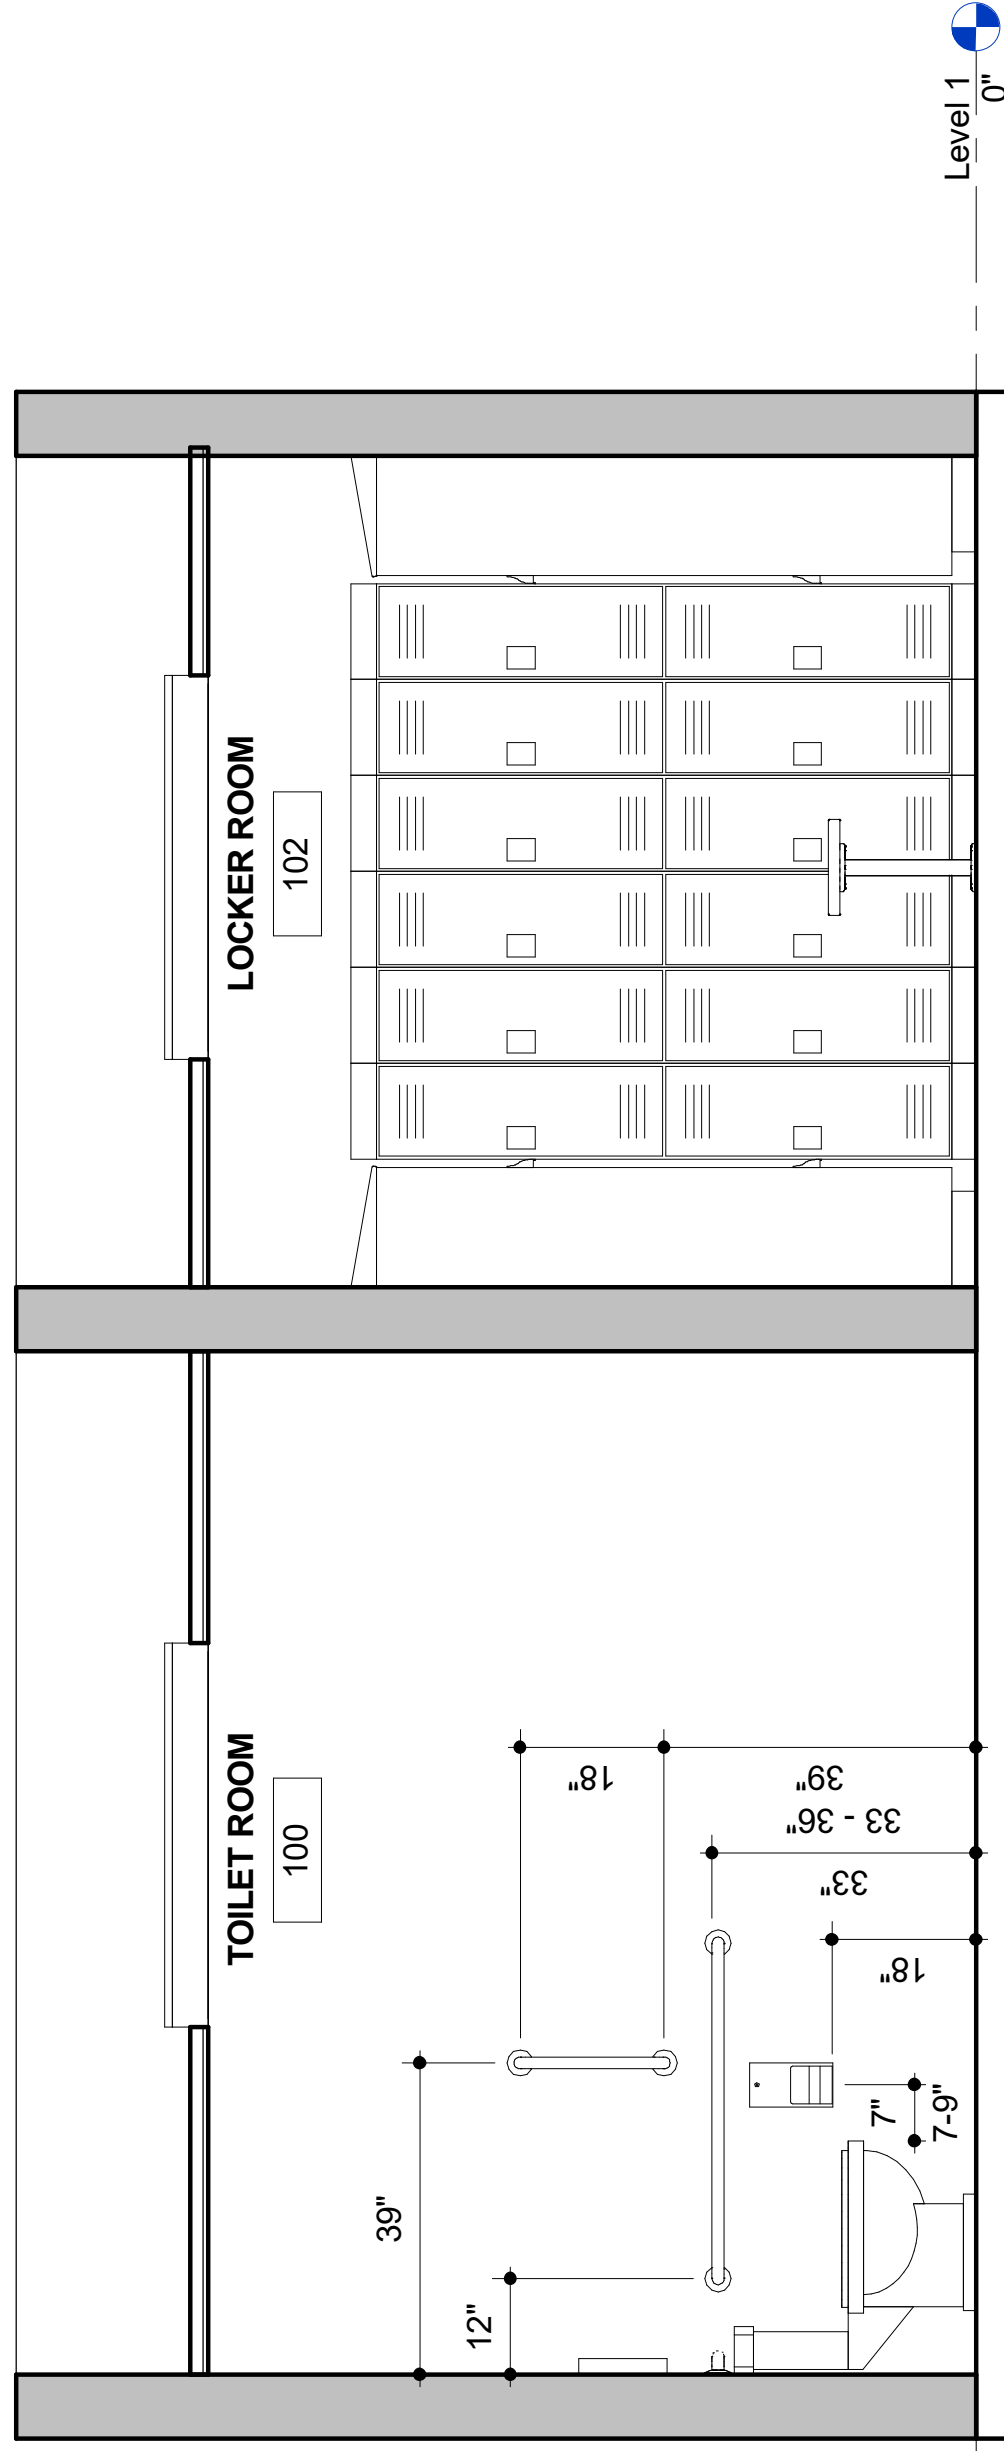

Level 1
0"

1 Section 1
1/2" = 1'-0"

Plumbing Fixture Schedule		
Count	Model	Description
1	ELX-2	Express™ Lavatory System – ELX Series, Two-Station
Grand total: 1		Bradley Corporation

Specialty Equipment Schedule		
Count	Model	Description
2	781-024360	Channel-Frame Mirror, Welded Corners, 24x36
1	2027-100000	Towel Dispenser/Waste Receptacle
2	5402	Toilet Tissue Dispenser
2	5831	Seat Cover Dispenser
1	8122-001180	Grab Bars
1	8122-001360	Grab Bars
1	8122-001420	Grab Bars
1	Bradmar - Urinal Screen 23x48	Restroom Partitions, Urinal Screen
1	Bradmar No-Site - Series 400 - Sentinel™	Restroom Partitions, Floor-Mounted with Overhead Brace
35	Lenox 2-Tier	Solid Plastic HDPE Locker
1	LENOXPEDESTAL 12x84	SOLID PLASTIC PEDESTAL BENCH
1	LENOXPEDESTAL 24x48 ADA	SOLID PLASTIC PEDESTAL BENCH - ADA
Grand total: 49		Bradley Corporation