




Bradley VDC-Assist
Virtual Design & Construction Assistance

Bradley Corporation
www.bradleycorp.com
Bradley BIM | Revit Support Portal
www.bradleybim.com
Bradley BIM | Revit Library
www.bradleycorp.com/bim
[1,000 Revit Families]

~ Bradley VDC-Assist ~
This is a conceptual 'Not for Construction' drawing set.
The client/owner is responsible for obtaining all federal, state and local code reviews, permits & approvals for this project.

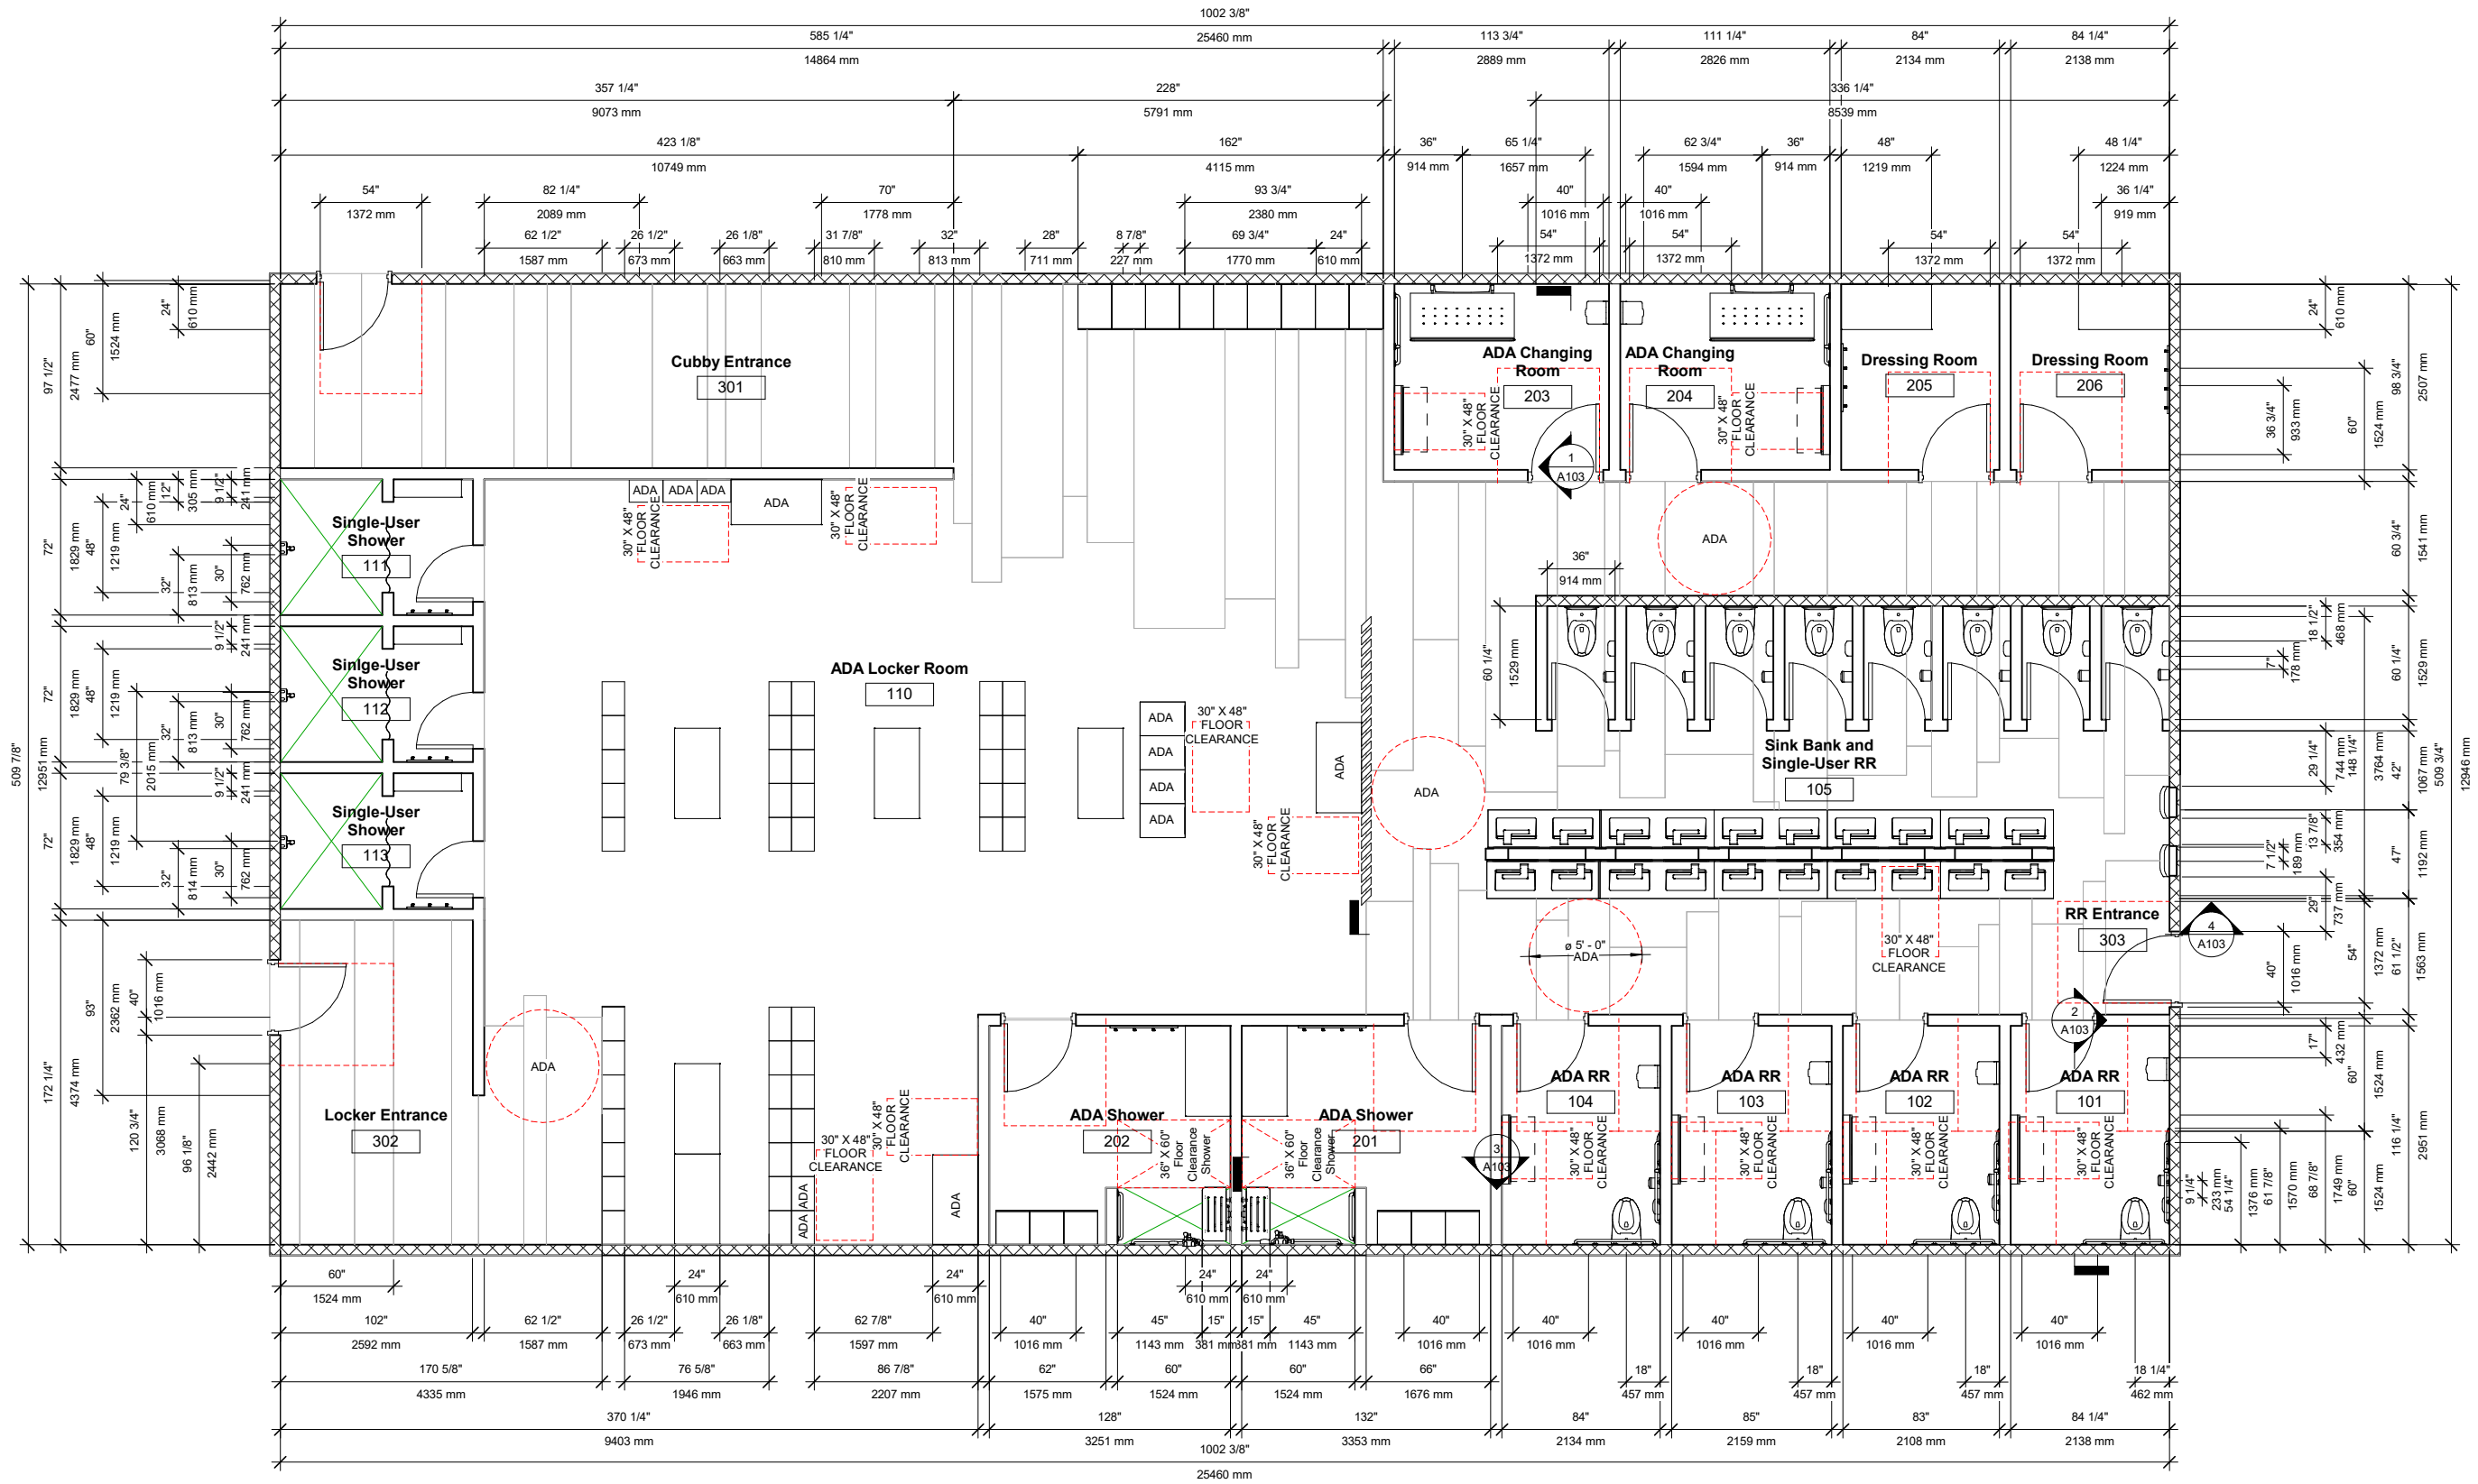

① Dimension Plan
1/4" = 1'-0"

This print contains information that is PROPRIETARY. Disclosure of any information on this document cannot be made without written permission of Bradley Corporation.

Bradley Corp.
ADA Family RR and
Locker Room
Dimension Plan

Project number	Project Number
Date	Issue Date
Model by	Author
Checked by	Checker
A101	
Scale	1/4" = 1'-0"


11/20/2023 1:32:21 PM



Bradley VDC-Assist
Virtual Design & Construction Assistance

Bradley Corporation
www.bradleycorp.com
Bradley BIM | Revit Support Portal
www.bradleybim.com
Bradley BIM | Revit Library
www.bradleycorp.com/bim
[1,000 Revit Families]

~ Bradley VDC-Assist ~
This is a conceptual 'Not for Construction' drawing set.
The client/owner is responsible for obtaining all federal, state and local code reviews, permits & approvals for this project.

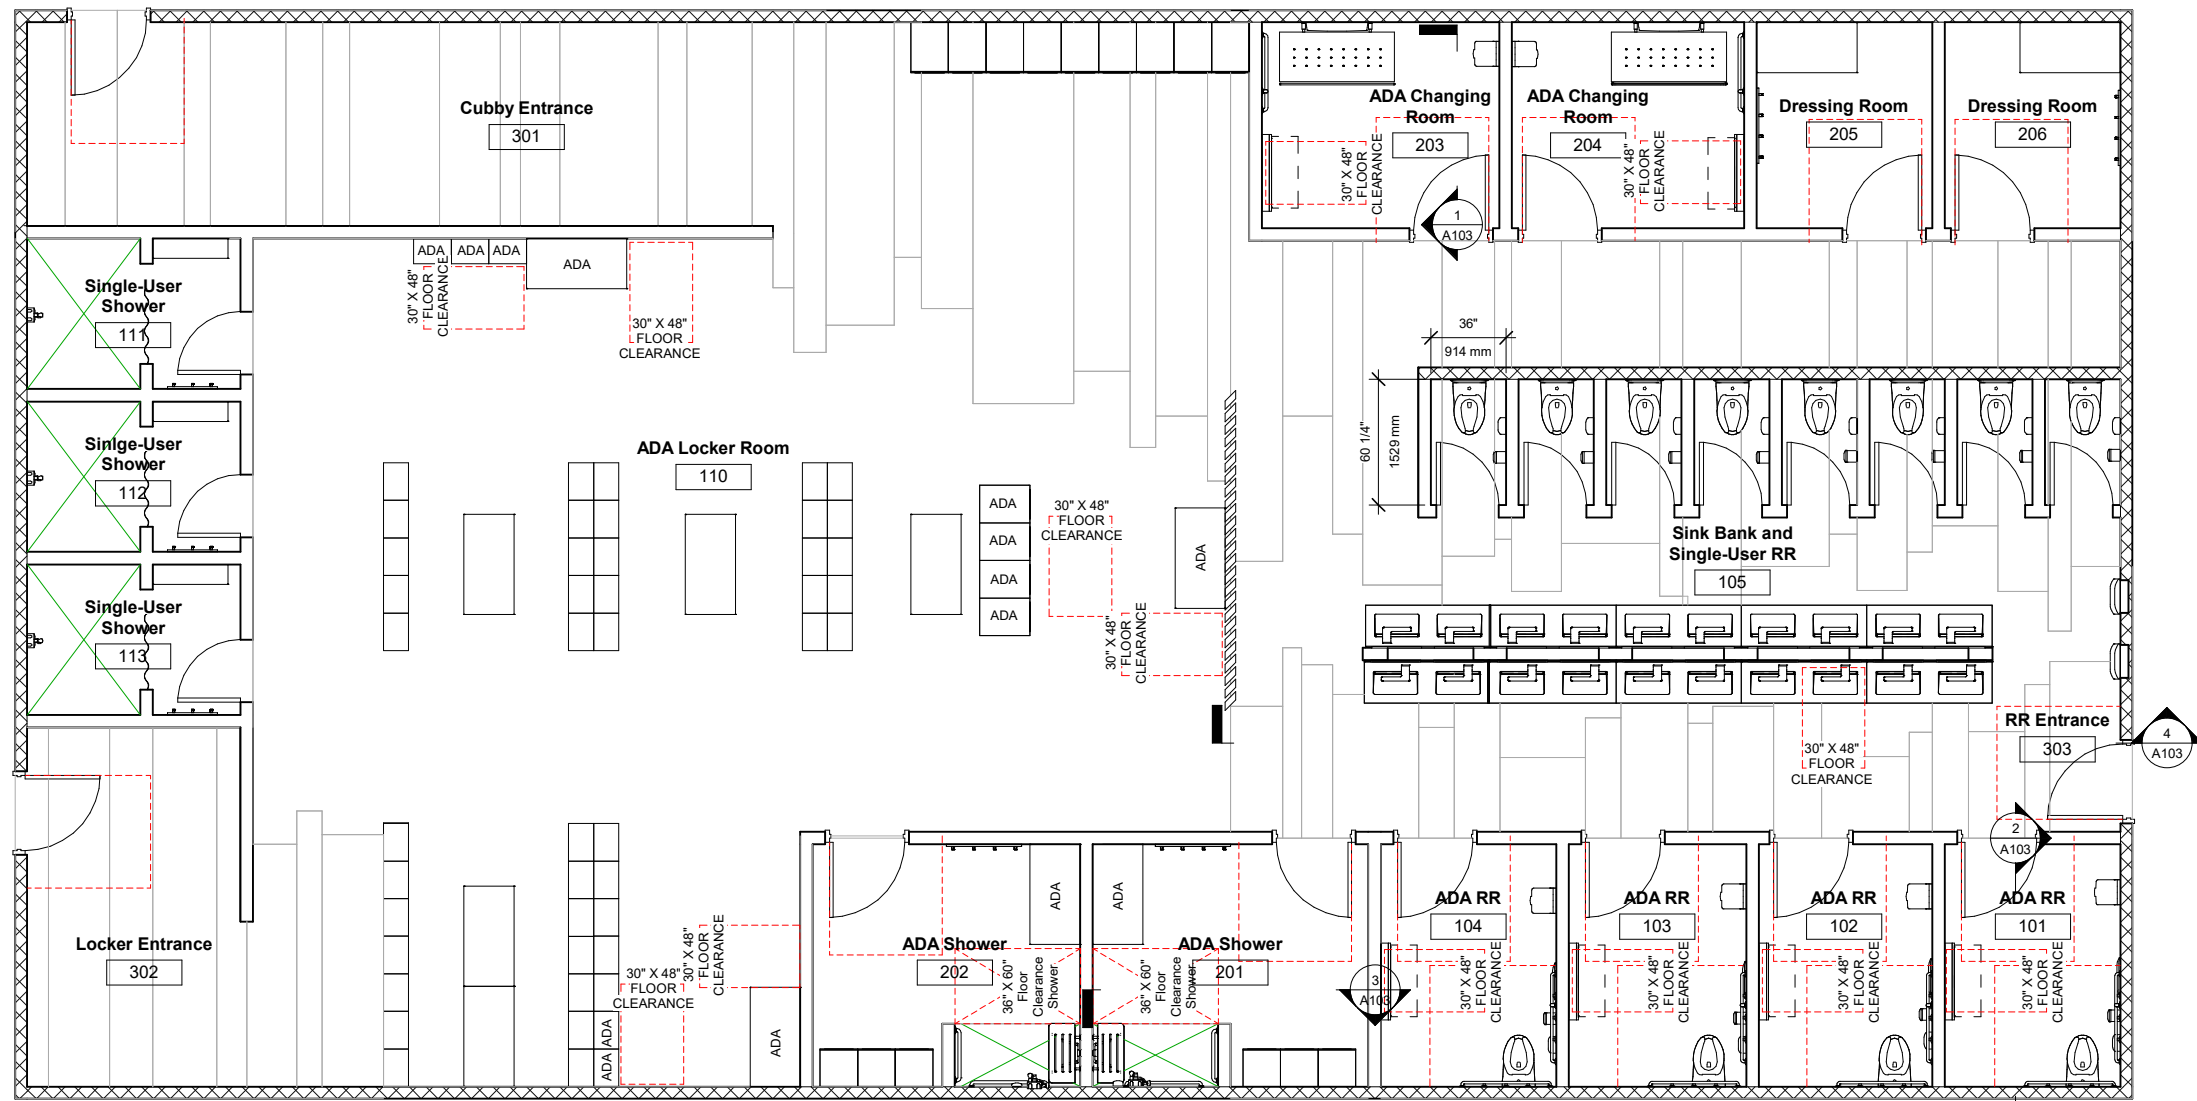

1 Floor Plan
1/4" = 1'-0"

Bradley Corp.
ADA Family RR and Locker Room
Floor Plan

Project number	Project Number
Date	Issue Date
Model by	Author
Checked by	Checker
A102	
Scale	1/4" = 1'-0"

This print contains information that is PROPRIETARY. Disclosure of any information on this document cannot be made without written permission of Bradley Corporation.


11/20/2023 1:22:23 PM




Bradley VDC-Assist
Virtual Design & Construction Assistance

Bradley Corporation
www.bradleycorp.com
Bradley BIM | Revit Support Portal
www.bradleybim.com
Bradley BIM | Revit Library
www.bradleycorp.com/bim
[1,000 Revit Families]


~ Bradley VDC-Assist ~
This is a conceptual 'Not for Construction' drawing set.
The client/owner is responsible for obtaining all federal, state and local code reviews, permits & approvals for this project.

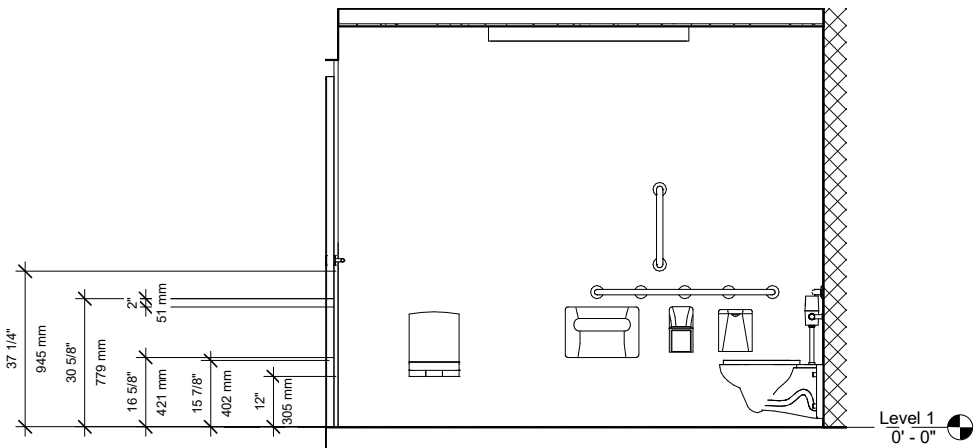


② ADA Restroom Accessories Heights
1/2" = 1'-0"

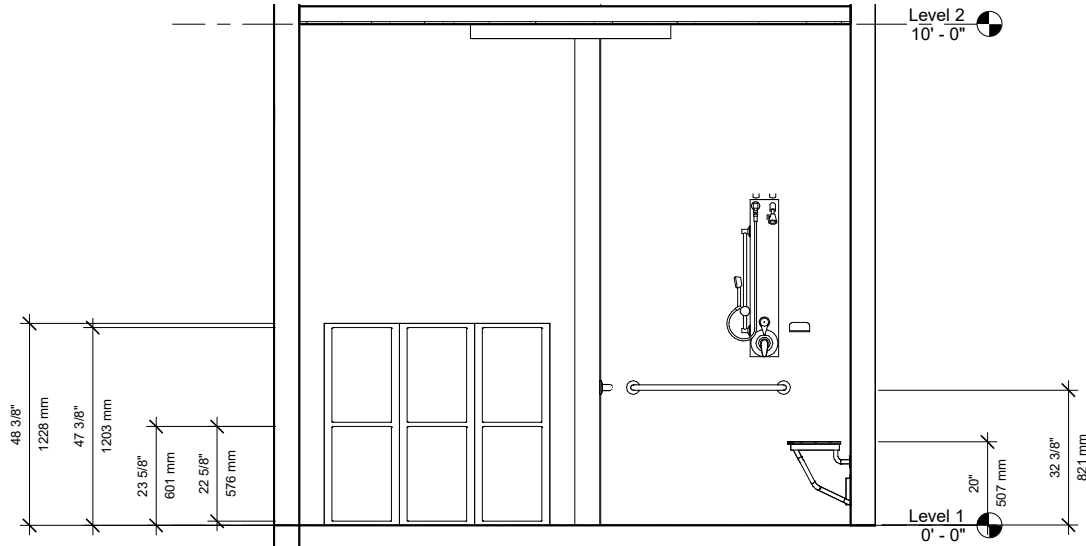

③ ADA Shower Section View
1/2" = 1'-0"

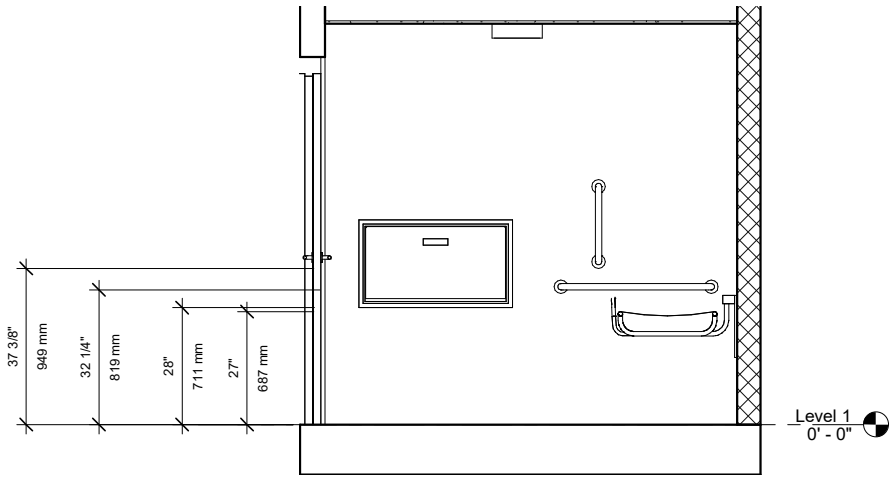

① ADA Changing Room Section View
1/2" = 1'-0"

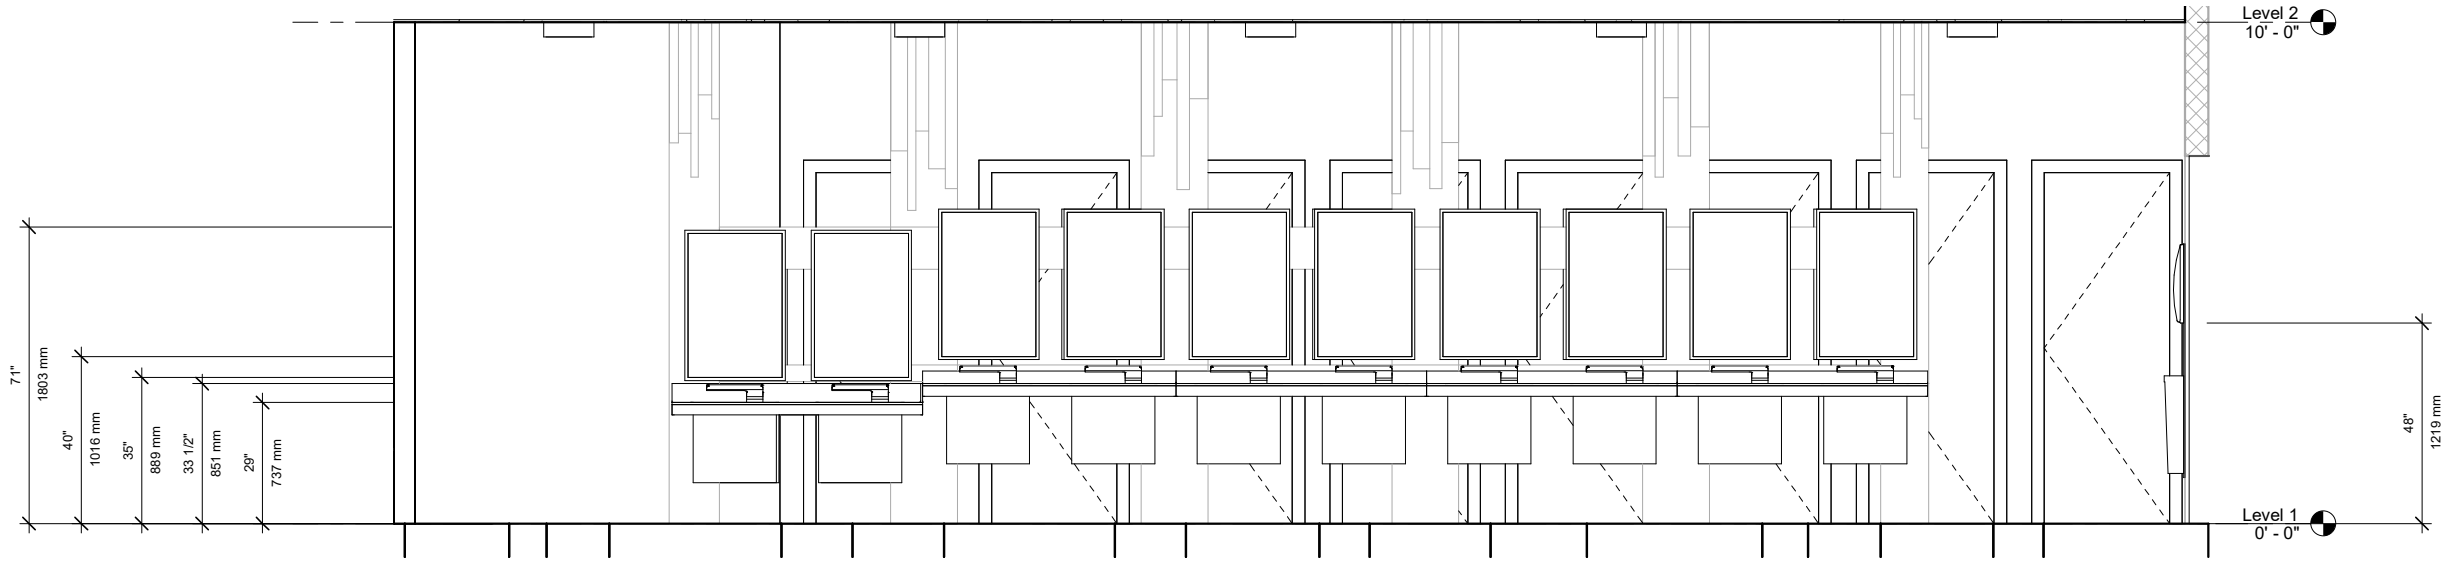

④ ADA Sink Bank Section View
1/2" = 1'-0"

Bradley Corp.
ADA Family RR and
Locker Room
Sections

Project number	Project Number
Date	Issue Date
Model by	Author
Checked by	Checker
A103	
Scale	1/2" = 1'-0"

This print contains information that is PROPRIETARY. Disclosure of any information on this document cannot be made without written permission of Bradley Corporation.

11/20/2023 1:32:24 PM




① Sink Bank and Single-User RR Rendering
12" = 1'-0"



③ Locker Room Rendering
12" = 1'-0"



② Sink Bank Rendering
12" = 1'-0"

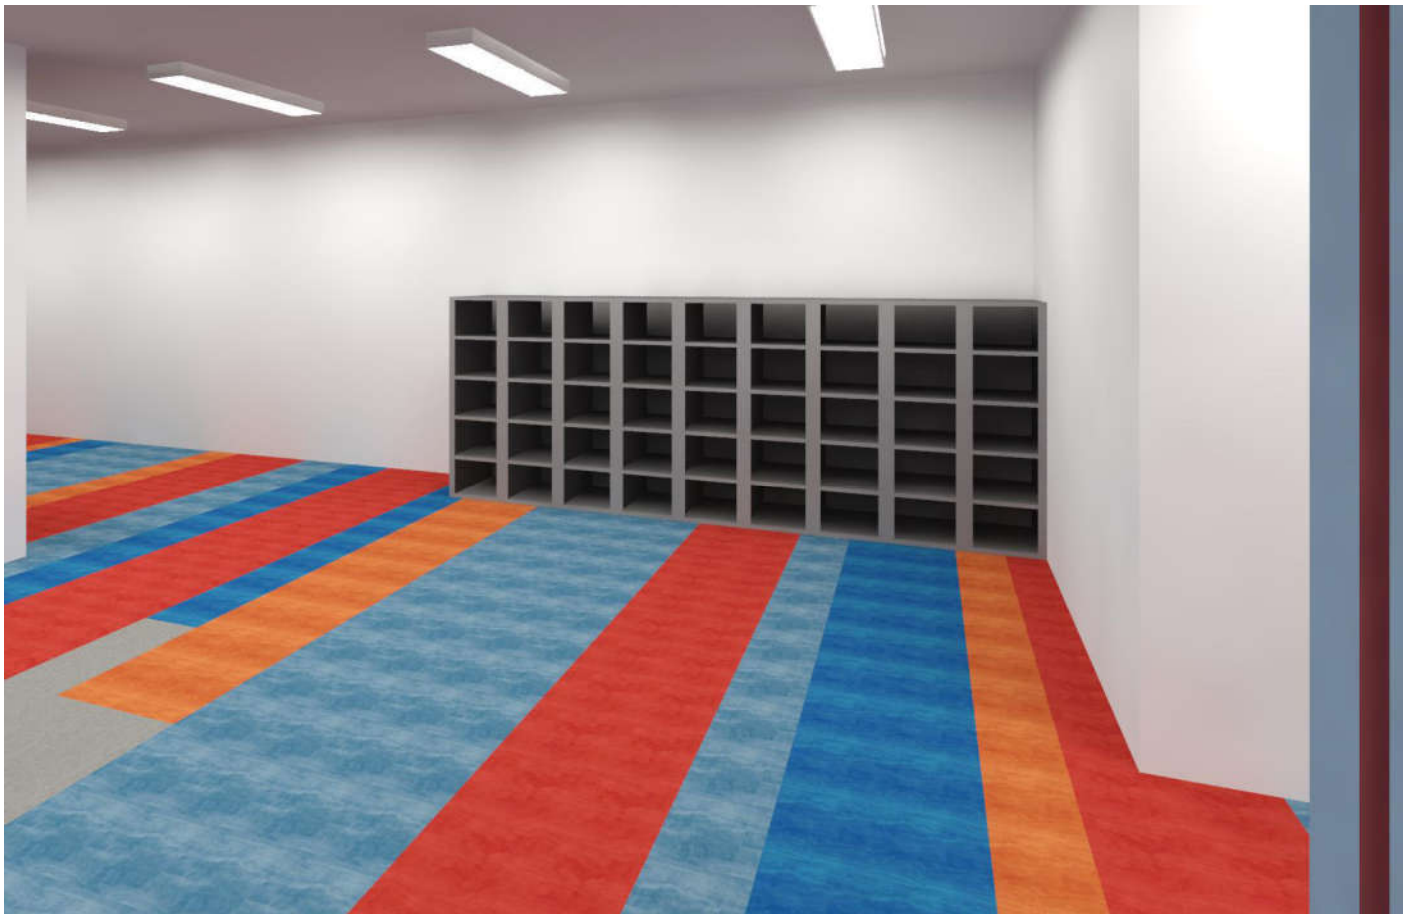

④ Cubby Locker Rendering
12" = 1'-0"



Bradley VDC-Assist
Virtual Design & Construction Assistance

Bradley Corporation
www.bradleycorp.com
Bradley BIM | Revit Support Portal
www.bradleybim.com
Bradley BIM | Revit Library
www.bradleycorp.com/bim
[1,000 Revit Families]

~ Bradley VDC-Assist ~
This is a conceptual 'Not for Construction' drawing set.
The client/owner is responsible for obtaining all federal, state and local code reviews, permits & approvals for this project.

Bradley Corp.
ADA Family RR and
Locker Room
Renderings

Project number	Project Number
Date	Issue Date
Model by	Author
Checked by	Checker
A104	
Scale	12" = 1'-0"

This print contains information that is PROPRIETARY. Disclosure of any information on this document cannot be made without written permission of Bradley Corporation.

11/20/2023 1:32:25 PM



① ADA Restroom Rendering
12" = 1'-0"



② ADA Shower Rendering
12" = 1'-0"



③ ADA Adult Changing Room
12" = 1'-0"



④ Changing Room
12" = 1'-0"



Bradley VDC-Assist
Virtual Design & Construction Assistance

Bradley Corporation

www.bradleycorp.com

Bradley BIM | Revit Support Portal
www.bradleybim.com

Bradley BIM | Revit Library
www.bradleycorp.com/bim
[1,000 Revit Families]

~ Bradley VDC-Assist ~

This is a conceptual 'Not for Construction' drawing set.

The client/owner is responsible for obtaining all federal, state and local code reviews, permits & approvals for this project.

Bradley Corp.
ADA Family RR and Locker Room
Renderings

Project number	Project Number
Date	Issue Date
Model by	Author
Checked by	Checker
A105	
Scale	12" = 1'-0"

This print contains information that is PROPRIETARY. Disclosure of any information on this document cannot be made without written permission of Bradley Corporation.

11/20/2023 1:32:31 PM



① Changing Station Entrance
12" = 1'-0"



② Cubby Entrance Rendering
12" = 1'-0"



Bradley VDC-Assist
Virtual Design & Construction Assistance

Bradley Corporation
www.bradleycorp.com
Bradley BIM | Revit Support Portal
www.bradleybim.com
Bradley BIM | Revit Library
www.bradleycorp.com/bim
[1,000 Revit Families]


~ Bradley VDC-Assist ~
This is a conceptual 'Not for Construction' drawing set.
The client/owner is responsible for obtaining all federal, state and local code reviews, permits & approvals for this project.

Bradley Corp.
ADA Family RR and
Locker Room
Renderings

Project number	Project Number
Date	Issue Date
Model by	Author
Checked by	Checker
A106	
Scale	12" = 1'-0"

This print contains information that is PROPRIETARY. Disclosure of any information on this document cannot be made without written permission of Bradley Corporation.

11/20/2023 1:32:41 PM

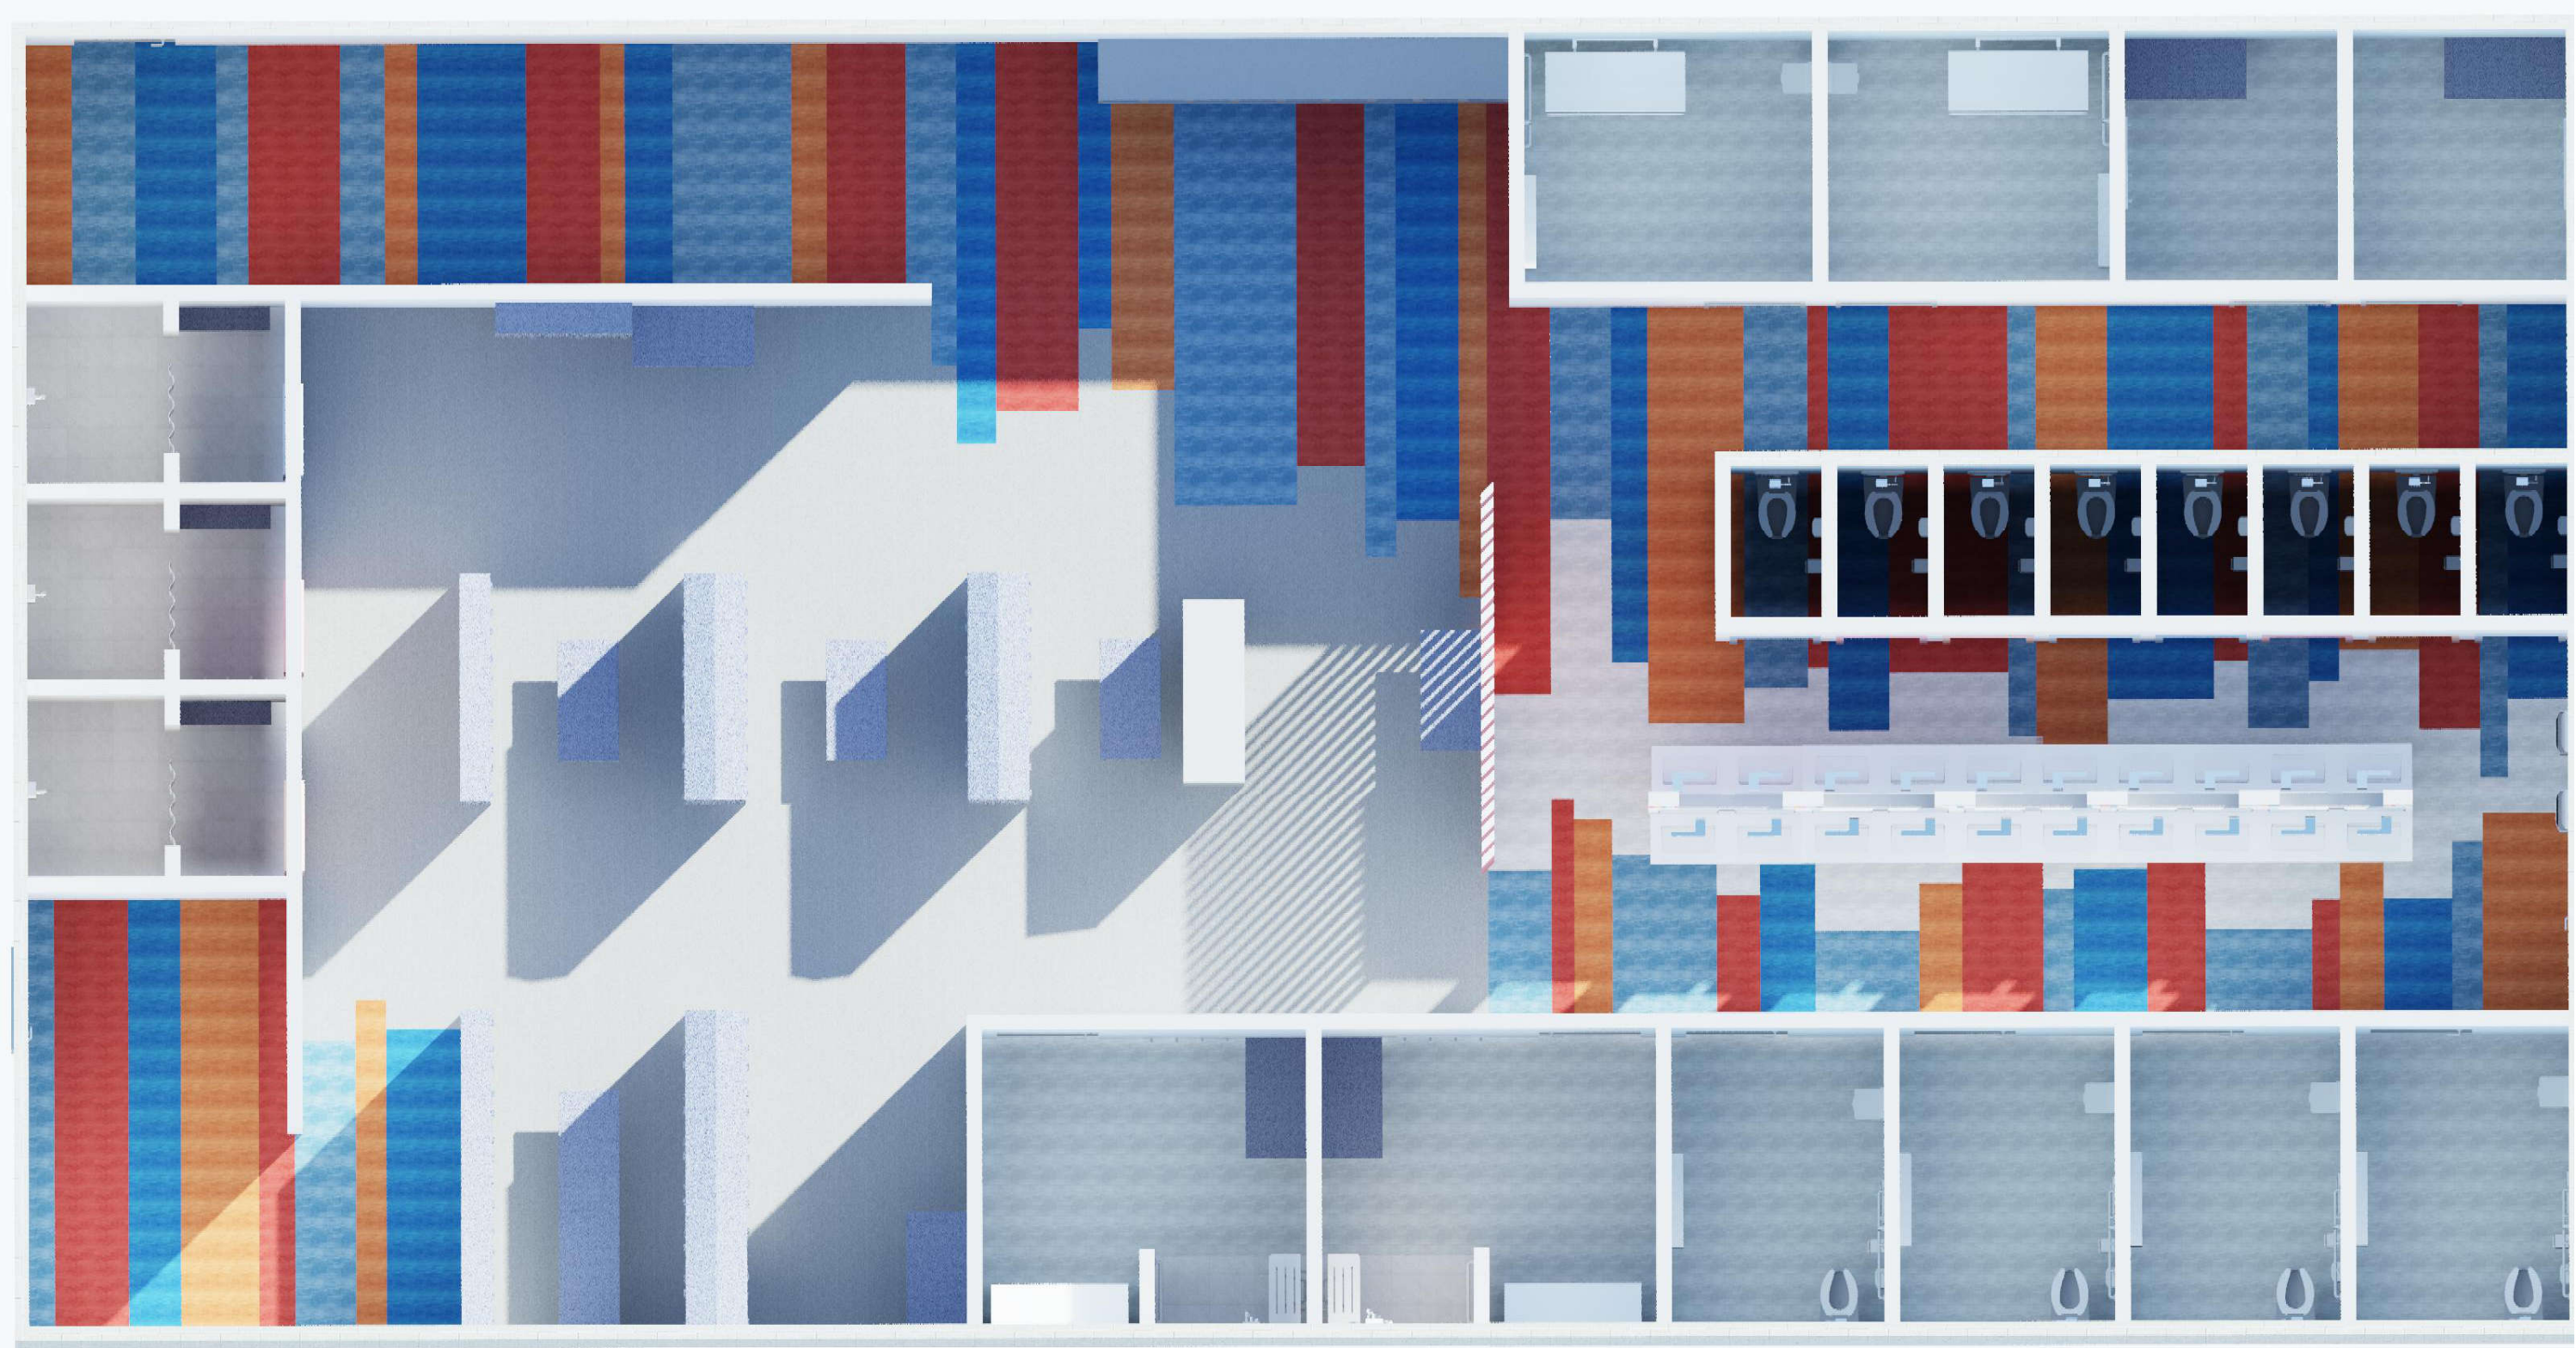

① Rendered Floor Plan
6" = 1'-0"



Bradley VDC-Assist

Virtual Design & Construction Assistance

Bradley Corporation
www.bradleycorp.com
Bradley BIM | Revit Support Portal
www.bradleybim.com
Bradley BIM | Revit Library
www.bradleycorp.com/bim
[1,000 Revit Families]

~ Bradley VDC-Assist ~
This is a conceptual 'Not for Construction' drawing set.
The client/owner is responsible for obtaining all federal, state and local code reviews, permits & approvals for this project.

Bradley Corp.
ADA Family RR and Locker Room
Rendered Floor Plan

Project number	Project Number
Date	Issue Date
Model by	Author
Checked by	Checker
A107	
Scale	6" = 1'-0"

This print contains information that is PROPRIETARY. Disclosure of any information on this document cannot be made without written permission of Bradley Corporation.

11/20/2023 1:32:46 PM



Bradley VDC-Assist
Virtual Design & Construction Assistance

Bradley Corporation
www.bradleycorp.com

Bradley BIM | Revit Support Portal
www.bradleybim.com

Bradley BIM | Revit Library
www.bradleycorp.com/bim
[1,000 Revit Families]

~ **Bradley VDC-Assist** ~
This is a conceptual 'Not for Construction' drawing set.
The client/owner is responsible for obtaining all federal, state and local code reviews, permits & approvals for this project.

Bradley Corp.
ADA Family RR and Locker Room

Schedules

Project number	Project Number
Date	Issue Date
Model by	Emma Ayers
Checked by	Checker
A108	
Scale	

Specialty Equipment Schedule				
Count	Family	Model	Product Tech Data URL - English	
2A05-000000: 2	2	Towel_Dispenser_Waste-Bradley_Corp-Diplomat_2A05	2A05-000000	https://www.bradleycorp.com/download/2001/9402.pdf
4A10: 12	12	Sanitary_Napkin_Disposal-Bradley_Corp-Surface-Diplomat-4A10 (2)	4A10	https://www.bradleycorp.com/download/2014/9413.pdf
5A10: 12	12	Toilet_Tissue_Dispenser-Bradley_Corp-Surface-Diplomat-5A10	5A10	https://www.bradleycorp.com/download/2017/9414.pdf
5A40: 12	12	Seat_Cover_Dispenser-Bradley_Corp-Diplomat-5A40 (1)	5A40	https://www.bradleycorp.com/download/2019/9417.pdf
962-11: 6	6	962_Baby_Changing_Station	962-11	
8120-001180: 6	6	812_Grab_Bars (1)	8120-001180	
8120-001240: 2	2	812_Grab_Bars (1)	8120-001240	
8120-001360: 1	1	812_Grab_Bars (1)	8120-001360	
8122-001360: 2	2	812_Grab_Bars (1)	8122-001360	
8320-106420: 8	8	<varies>	8320-106420	https://www.bradleycorp.com/download/5028/Bradley_GrabBar_Bariatric_8320-106420.pdf
8322-001360: 1	1	832_Grab_Bars (5)	8322-001360	
9533 36" x 72": 3	3	Shower_Curtain-Bradley_Corp-9533-9535-9537	9533 36" x 72"	
9562: 2	2	Shower_Seat-Bradley_Corp-Phenolic-9562	9562	
9611: 6	6	Toddler_Seat-Bradley_Corporation-Wall_964	9611	
9943 BradEX: 3	3	Hat_Coat_Rack-Bradley_Corp-Stainless-994x (2)	9943 BradEX	http://bradleycorp.com/download/525/9150.pdf
9944: 4	4	Hat_Coat_Rack-Bradley_Corp-Stainless-994x (2)	9944	http://bradleycorp.com/download/525/9150.pdf
9944: 4	20	Bradley-Washroom_Accessories-Mirrors-780_Standard (1)		
ERROR - If you are able to see this message you haven't loaded this family correctly.: 20	49		ERROR - If you are able to see this message you haven't loaded this family correctly.	
Lenox "Z" Locker: 49	49	Locker-Bradley_Corp-Lenox-Z_Locker	Lenox "Z" Locker	http://bradleycorp.com/download/33/9827.pdf
LENOXCUBBY: 19	19	<varies>	LENOXCUBBY	http://bradleycorp.com/download/36/9860.pdf
LENOXPEDESTAL: 15	15	Locker_Room_Bench-Pedestal-Bradley_Corp-Lenox_Pedestal	LENOXPEDESTAL	http://bradleycorp.com/download/38/9850.pdf
R8406: 2	2	Pressalit Nursing Bench 1000 fixed height	R8406	
R8410: 2	2	Safety Rail for Nursing Bench 1000	R8410	

Plumbing Fixture Schedule			
Count	Family	Model	Product Tech Data URL - English
1	Wall_Hung_Flushometer_Toilet_-_TOTO_-_CT708E	CT708E	
1	Wall_Hung_Flushometer_Toilet_-_TOTO_-_CT708E	CT708E	
1	Wall_Hung_Flushometer_Toilet_-_TOTO_-_CT708E	CT708E	
1	Wall_Hung_Flushometer_Toilet_-_TOTO_-_CT708E	CT708E	
1	Shower-Wall-Bradley_Corp-ADA_Individual_Pivoting-WS-1X-HN	This family is not loaded correctly	
1	Shower-Wall-Bradley_Corp-ADA_Individual_Pivoting-WS-1X-HN	This family is not loaded correctly	
1	Sink-Bradley_Corp-Omnideck_LD-5010_WashBar_2Bowl	LD5010-WB-TR1 2-Basin	https://www.bradleycorp.com/download/1152/Bradley_Sink_OmniDeck_LD-3010.pdf
1	Sink-Bradley_Corp-Omnideck_LD-5010_WashBar_2Bowl	LD5010-WB-TR1 2-Basin	https://www.bradleycorp.com/download/1152/Bradley_Sink_OmniDeck_LD-3010.pdf
1	Shower-Wall-Bradley_Corp-Individual_Pivoting-WS-1X	WS-1X-HD-B1	
1	Shower-Wall-Bradley_Corp-Individual_Pivoting-WS-1X	WS-1X-HD-B1	
1	Shower-Wall-Bradley_Corp-Individual_Pivoting-WS-1X	WS-1X-HD-B1	
1	Wall_Hung_Flushometer_Toilet_-_TOTO_-_CT708E	CT708E	
1	Wall_Hung_Flushometer_Toilet_-_TOTO_-_CT708E	CT708E	
1	Wall_Hung_Flushometer_Toilet_-_TOTO_-_CT708E	CT708E	
1	Wall_Hung_Flushometer_Toilet_-_TOTO_-_CT708E	CT708E	
1	Wall_Hung_Flushometer_Toilet_-_TOTO_-_CT708E	CT708E	
1	Wall_Hung_Flushometer_Toilet_-_TOTO_-_CT708E	CT708E	
1	Wall_Hung_Flushometer_Toilet_-_TOTO_-_CT708E	CT708E	
1	Wall_Hung_Flushometer_Toilet_-_TOTO_-_CT708E	CT708E	